


APPENDIX J – Issued for Information Only Drawings

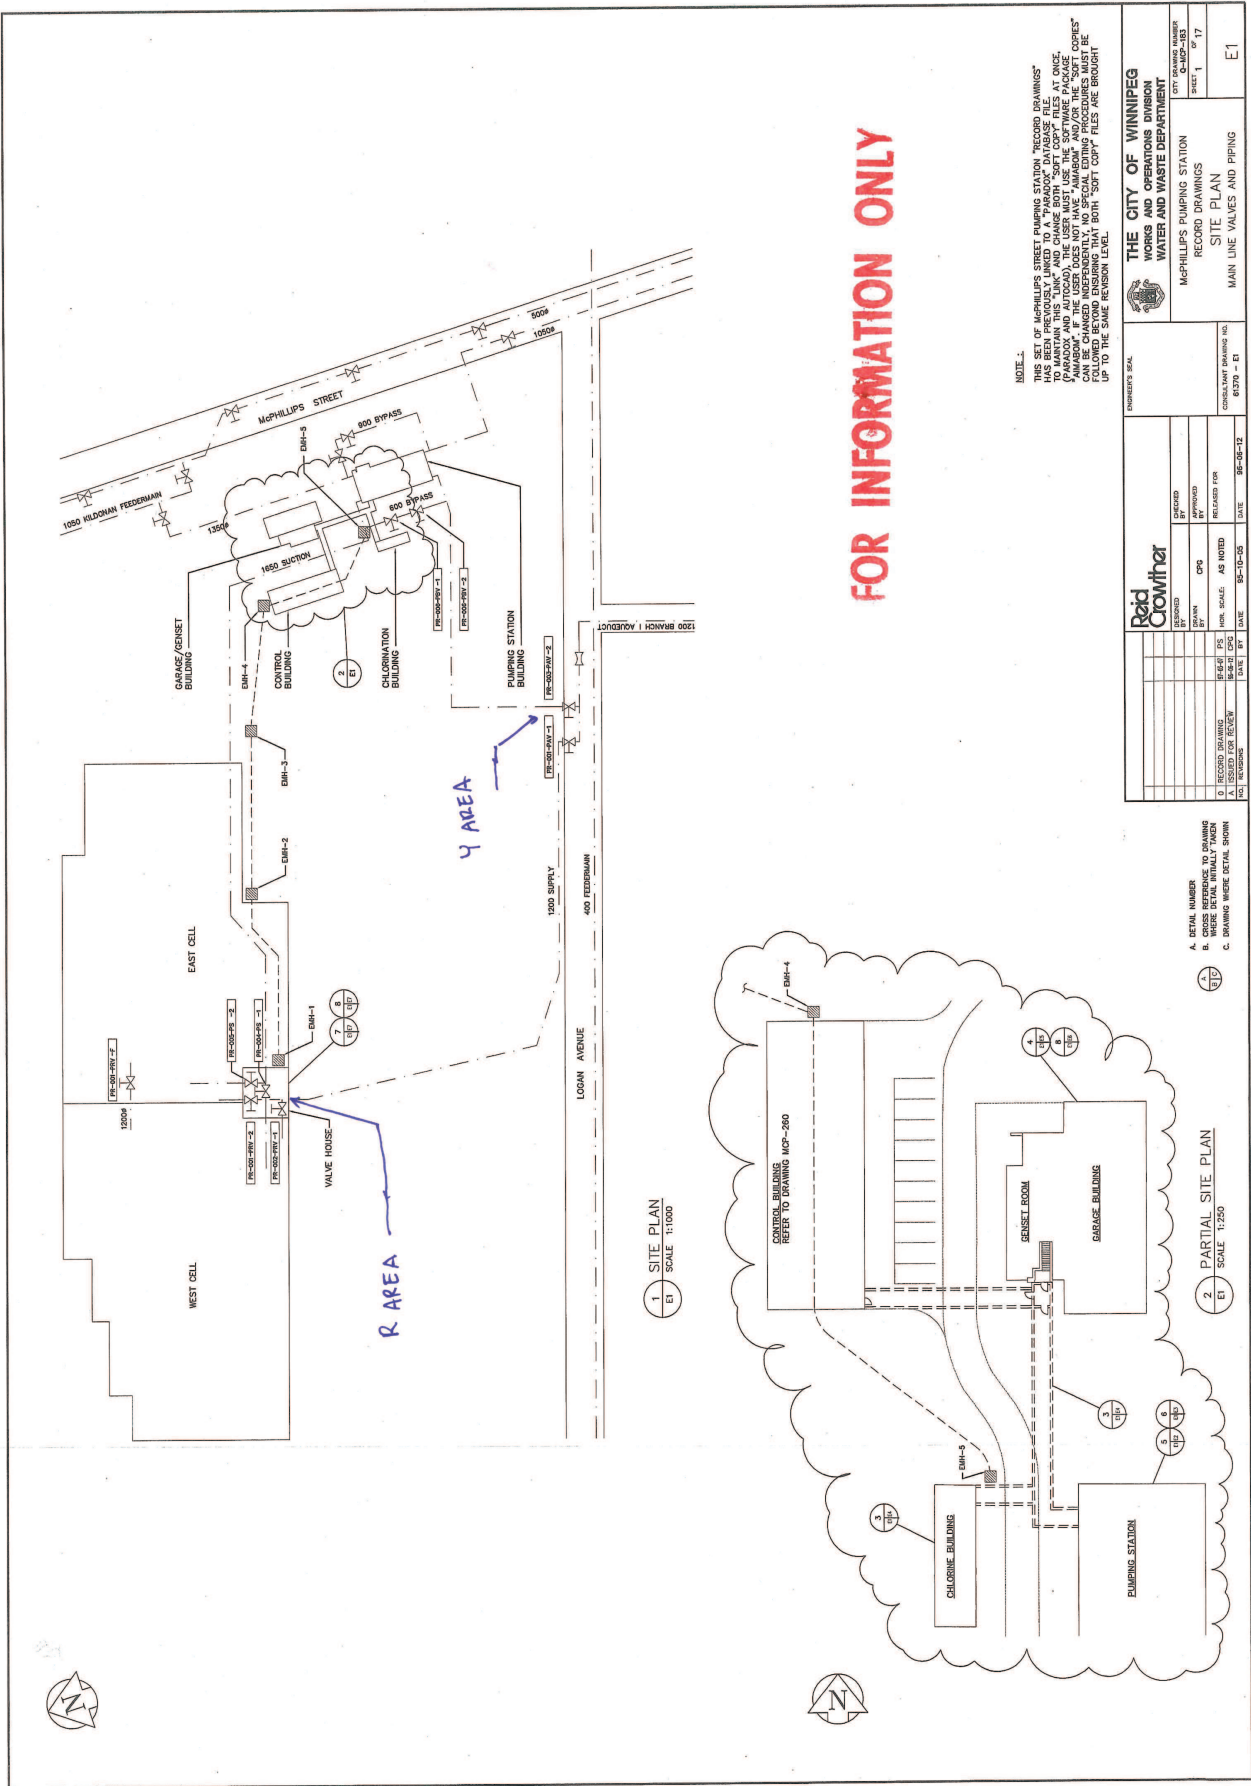

FOR INFORMATION ONLY

NOTE 2:
 THIS SET OF McPHILLIPS STREET PUMPING STATION "RECORD DRAWINGS" HAS BEEN PREVIOUSLY LINKED TO A "PARADOX" DATABASE FILE. IN ORDER TO VIEW THESE RECORD DRAWINGS, THE USER MUST USE THE SOFTWARE PACKAGE (PARADOX AND AUTOCAD). THE USER MUST USE THE "SOFT COPIES" AMBIGUOUS, IF THE USER DOES NOT HAVE "AMBIGUOUS" AND/OR THE "SOFT COPIES" SOFTWARE PACKAGE, THE USER MUST CONTACT THE CONSULTANT TO BE FOLLOWED BEYOND ENSURING THAT BOTH "SOFT COPY" FILES ARE BROUGHT UP TO THE SAME REVISION LEVEL.

THE CITY OF WINNIPEG WORKS AND OPERATIONS DIVISION WATER AND WASTE DEPARTMENT		CITY DRAWING NUMBER 6179 - E1 SHEET 1 OF 17
McPHILLIPS PUMPING STATION RECORD DRAWINGS SITE PLAN MAIN LINE VALVES AND PIPING		CONSULTANT DRAWING NO. 6179 - E1
REVISIONS NO. DATE BY DESCRIPTION	APPROVED BY DATE	RELEASED FOR DATE

1 SITE PLAN
 SCALE 1:1000

2 PARTIAL SITE PLAN
 SCALE 1:250

- A. DETAIL NUMBER
- B. CROSS REFERENCE TO DRAWING
- C. DRAWING WHERE DETAIL SHOWN