

**LEGEND**

- EXISTING
- NEW WORK

**CONSTRUCTION NOTES:**

- 1 PROVIDE AND INSTALL NEW HOUSEKEEPING PAD FOR DISTRIBUTION PANEL DP-B701. REFER TO DRAWING 1-0640B-E0005 FOR INSTALLATION DETAILS.
- 2 PROVIDE AND INSTALL NEW 600V, 400A, 3Ø, 3W, SQUARE D TYPE HCN DISTRIBUTION PANEL, DP-B701.

**GENERAL NOTES:**


1. REFER TO DRAWING 1-0640B-E0002 FOR DEMOLITION WORK IN ELECTRICAL ROOM.
2. REFER TO ASBESTOS REPORTS IN APPENDIX B. ASBESTOS IS PRESENT IN AND/OR PRESUMED TO BE PRESENT IN (BUT NOT LIMITED TO) THE FOLLOWING:

FLOOR : TERRAZZO SURFACE

WALL : DRYWALL  
VERMICULITE INSULATION (MASONRY)  
PLASTER (CERAMIC TILES & PREFORMED BLOCK)  
ADHESIVE/MASTIC (CERAMIC TILES)

**ELECTRICAL ROOM: ELECTRICAL PLAN LAYOUT**

SCALE: 1 : 20

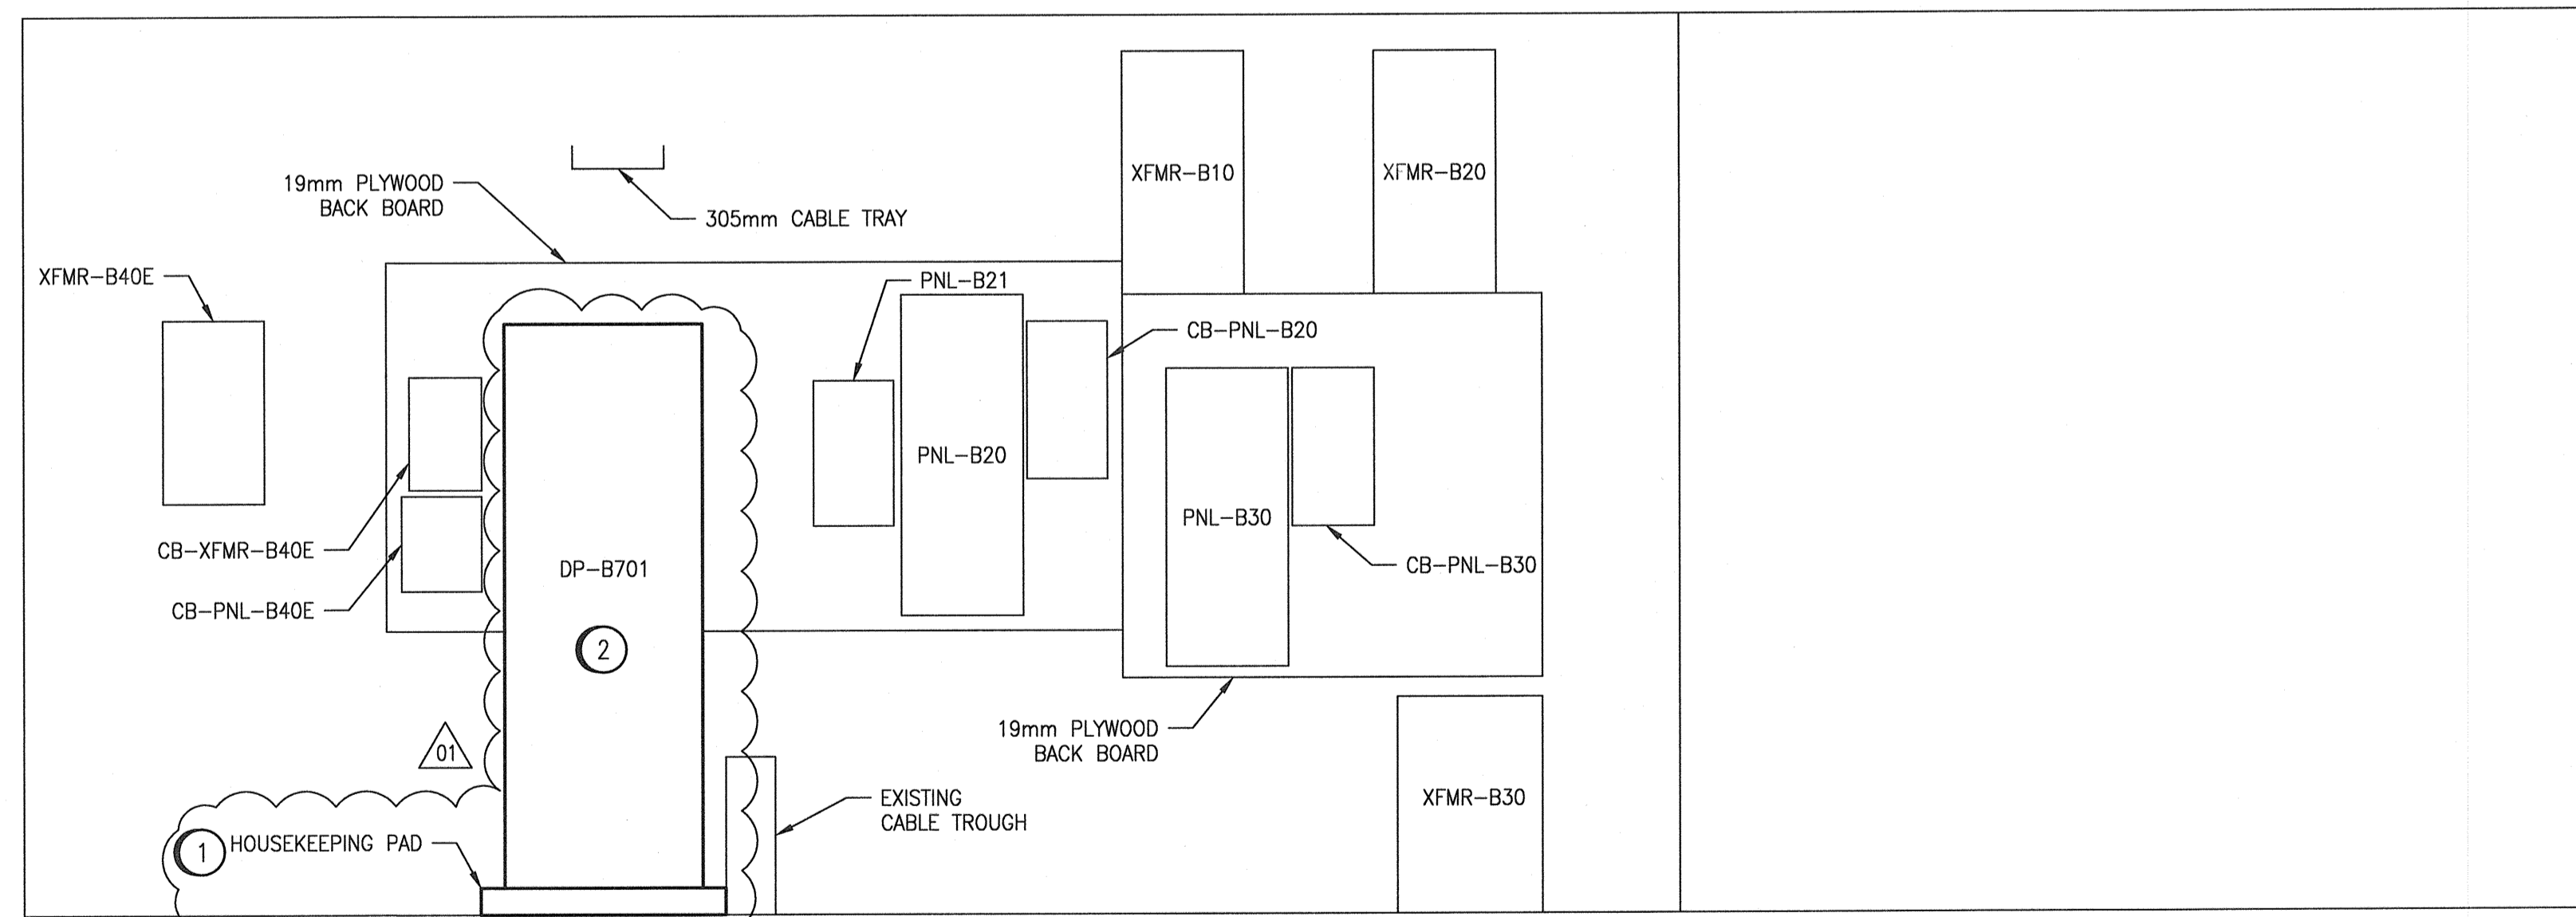

**WEST WALL ELEVATION**

SCALE: 1:20

**NORTH WALL ELEVATION**

 
SCALE: 1:20

**NOTES:**

1. THIS DRAWING SUPERSEDES DRAWING Q-MCP-188.
2. THIS DRAWING IS BASED ON EXISTING DOCUMENTATION.
3. CLOUDED PORTIONS OF THIS DRAWING INDICATE WORK TO BE COMPLETED - EITHER REMOVALS OR ADDITION AS INDICATED. REFER TO DEMOLITION AND CONSTRUCTION NOTES.

**METRIC**

WHOLE NUMBERS INDICATE MILLIMETRES  
DECIMALIZED NUMBERS INDICATE METRES



1:20




1-0640B-E0004	PANEL SCHEDULE AND LAYOUT, COLLECTION BUILDING DP-B701
1-0640B-E0005	PLAN AND SECTIONS DP-B701 HOUSEKEEPING PAD
1-0640B-E0002	PLAN LAYOUT AND ELEVATION, DEMOLITION
1-0640B-E0001	ELECTRICAL SINGLE LINE DIAGRAM, COLLECTIONS BUILDING

DRAWING NUMBER REFERENCE DRAWINGS

NO.	REVISIONS	DATE	DESIGN	CHECK
01	ISSUED FOR TENDER AND CONSTRUCTION	2019/10/18	VE	KS
00	ISSUED FOR CONSTRUCTION	2017/08/01	BJC	BJC

		SNC-LAVALIN INC. 148 Noture Park Way Winnipeg, MB, Canada R3P 0X7 204-786-8080	
DESIGNED BY: B. CLEVEN	CHECKED BY: B. CLEVEN	DATE: 2011/07/08	ISSUED FOR CONSTRUCTION BY: A. WEISS DATE: 2019/10/18
DRAWN BY: S. FUNK	APPROVED BY: B. CLEVEN	SCALE: 1:20	CONSULTANT NO.:

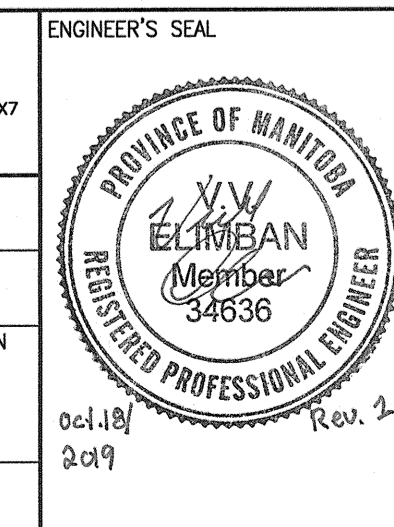

THE CITY OF WINNIPEG WATER AND WASTE DEPARTMENT			
MCPHILLIPS PUMPING STATION PLAN LAYOUT AND EQUIPMENT ELEVATION COLLECTIONS BUILDING ELECTRICAL ROOM - NEW WORK			
CITY DRAWING NUMBER 1-0640B-E0003	SHEET 001	REV. 01	SIZE A1