


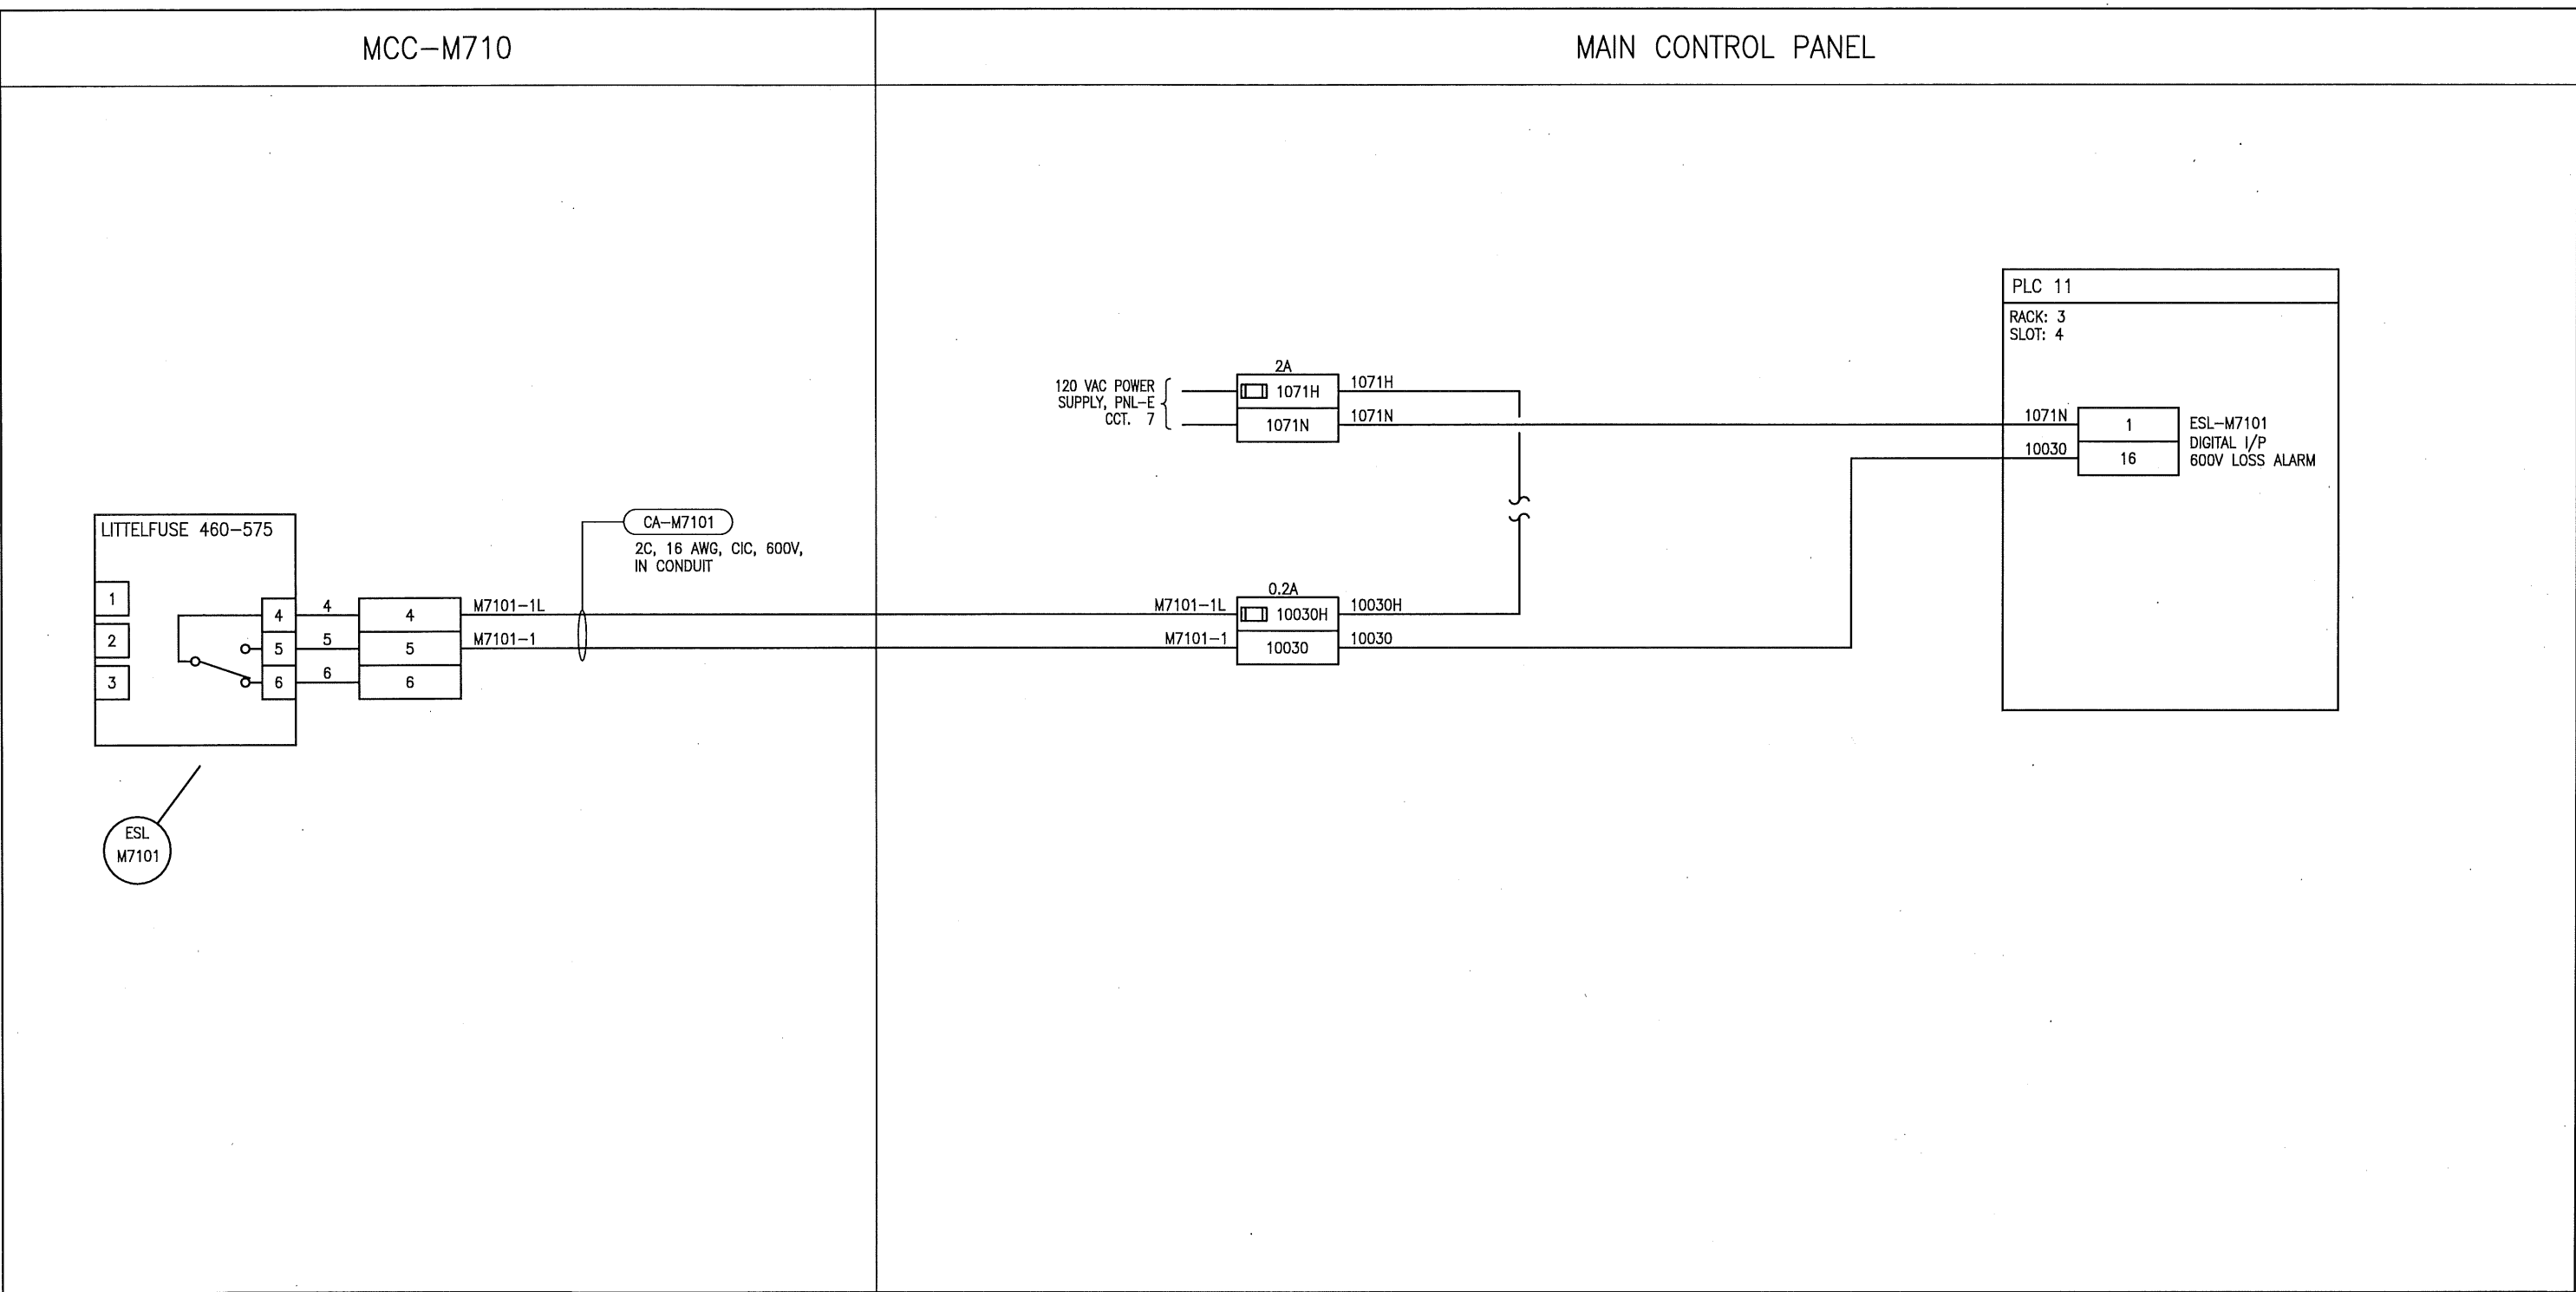

LAST SAVE: 2019/10/29 - 7:22am  
 PATH: M:\661472\4ENG\48C\DD - General DWG\02 Tache\1-0660M-A0004-001-00.dwg  
 B SIZE - 279mm x 432mm



**NOTES**

1. DRY CONTACT IS CLOSED WHEN 600V POWER IS PRESENT.
2. THIS DRAWING SUPERSEDES DWG. D-3426.
3. REFER TO DWG. 1-0660M-ED007 , ELECTRICAL SINGLE LINE DIAGRAM MCC-M710.


  
 SNC-Lavalin Inc.  
 No. 4489

				
00	ISSUED FOR TENDER AND CONSTRUCTION	2019/10/18	SB	BC
NO.	REVISIONS	DATE	DESIGN	CHECK


**SNC-LAVALIN INC.**  
 148 Nature Park Way  
 Winnipeg, MB, Canada R3P 0X7  
 204-786-8080

DESIGNED BY: S. BOGHOSIAN	CHECKED BY: B. CLEVEN
DRAWN BY: J. GRAGASIN	APPROVED BY: D. BECKER
SCALE: NTS	DATE: 2019/05/24
ISSUED FOR CONSTRUCTION	
BY: A. WEISS	DATE: 2019/10/18
CONSULTANT NO.:	

ENGINEER'S SEAL

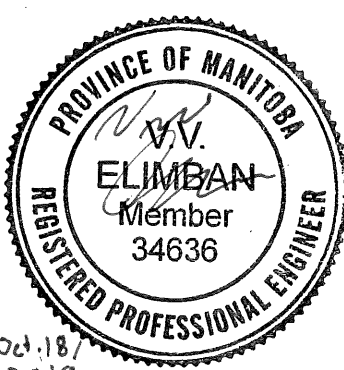

02.18/2019


**THE CITY OF WINNIPEG**  
 WATER AND WASTE DEPARTMENT

TACHE BOOSTER PUMPING STATION

LOOP DIAGRAM  
MCC-M710 VOLTAGE PRESENT

CITY DRAWING NUMBER	SHEET	REV.	SIZE
1-0660M-A0004	001	00	B