



**KEY NOTES**

1 EXISTING REFLECTIVE BLANKETS TO BE REMOVED BY GENERAL CONTRACTOR. PROVIDE SPRINKLER COVERAGE OVER RINK AREA AS PER NFPA REQUIREMENTS. PIPING SHALL BE ROUTED AND SPRINKLERS INSTALLED AT HIGH LEVEL. COORDINATE PIPING AND SPRINKLER INSTALLATION WITH GENERAL CONTRACTOR.

**PUBLICCITY**


Public City Architecture Inc  
 11-600 Clifton Street  
 Winnipeg, Manitoba  
 R3G 2X6 204 475 9323  
 publiccityarchitecture.com

Rev. No. Date Revision Notes  
 0 19-11-06 Issued for Construction  
 1 19-12-09 Issued with ADD1ME

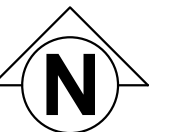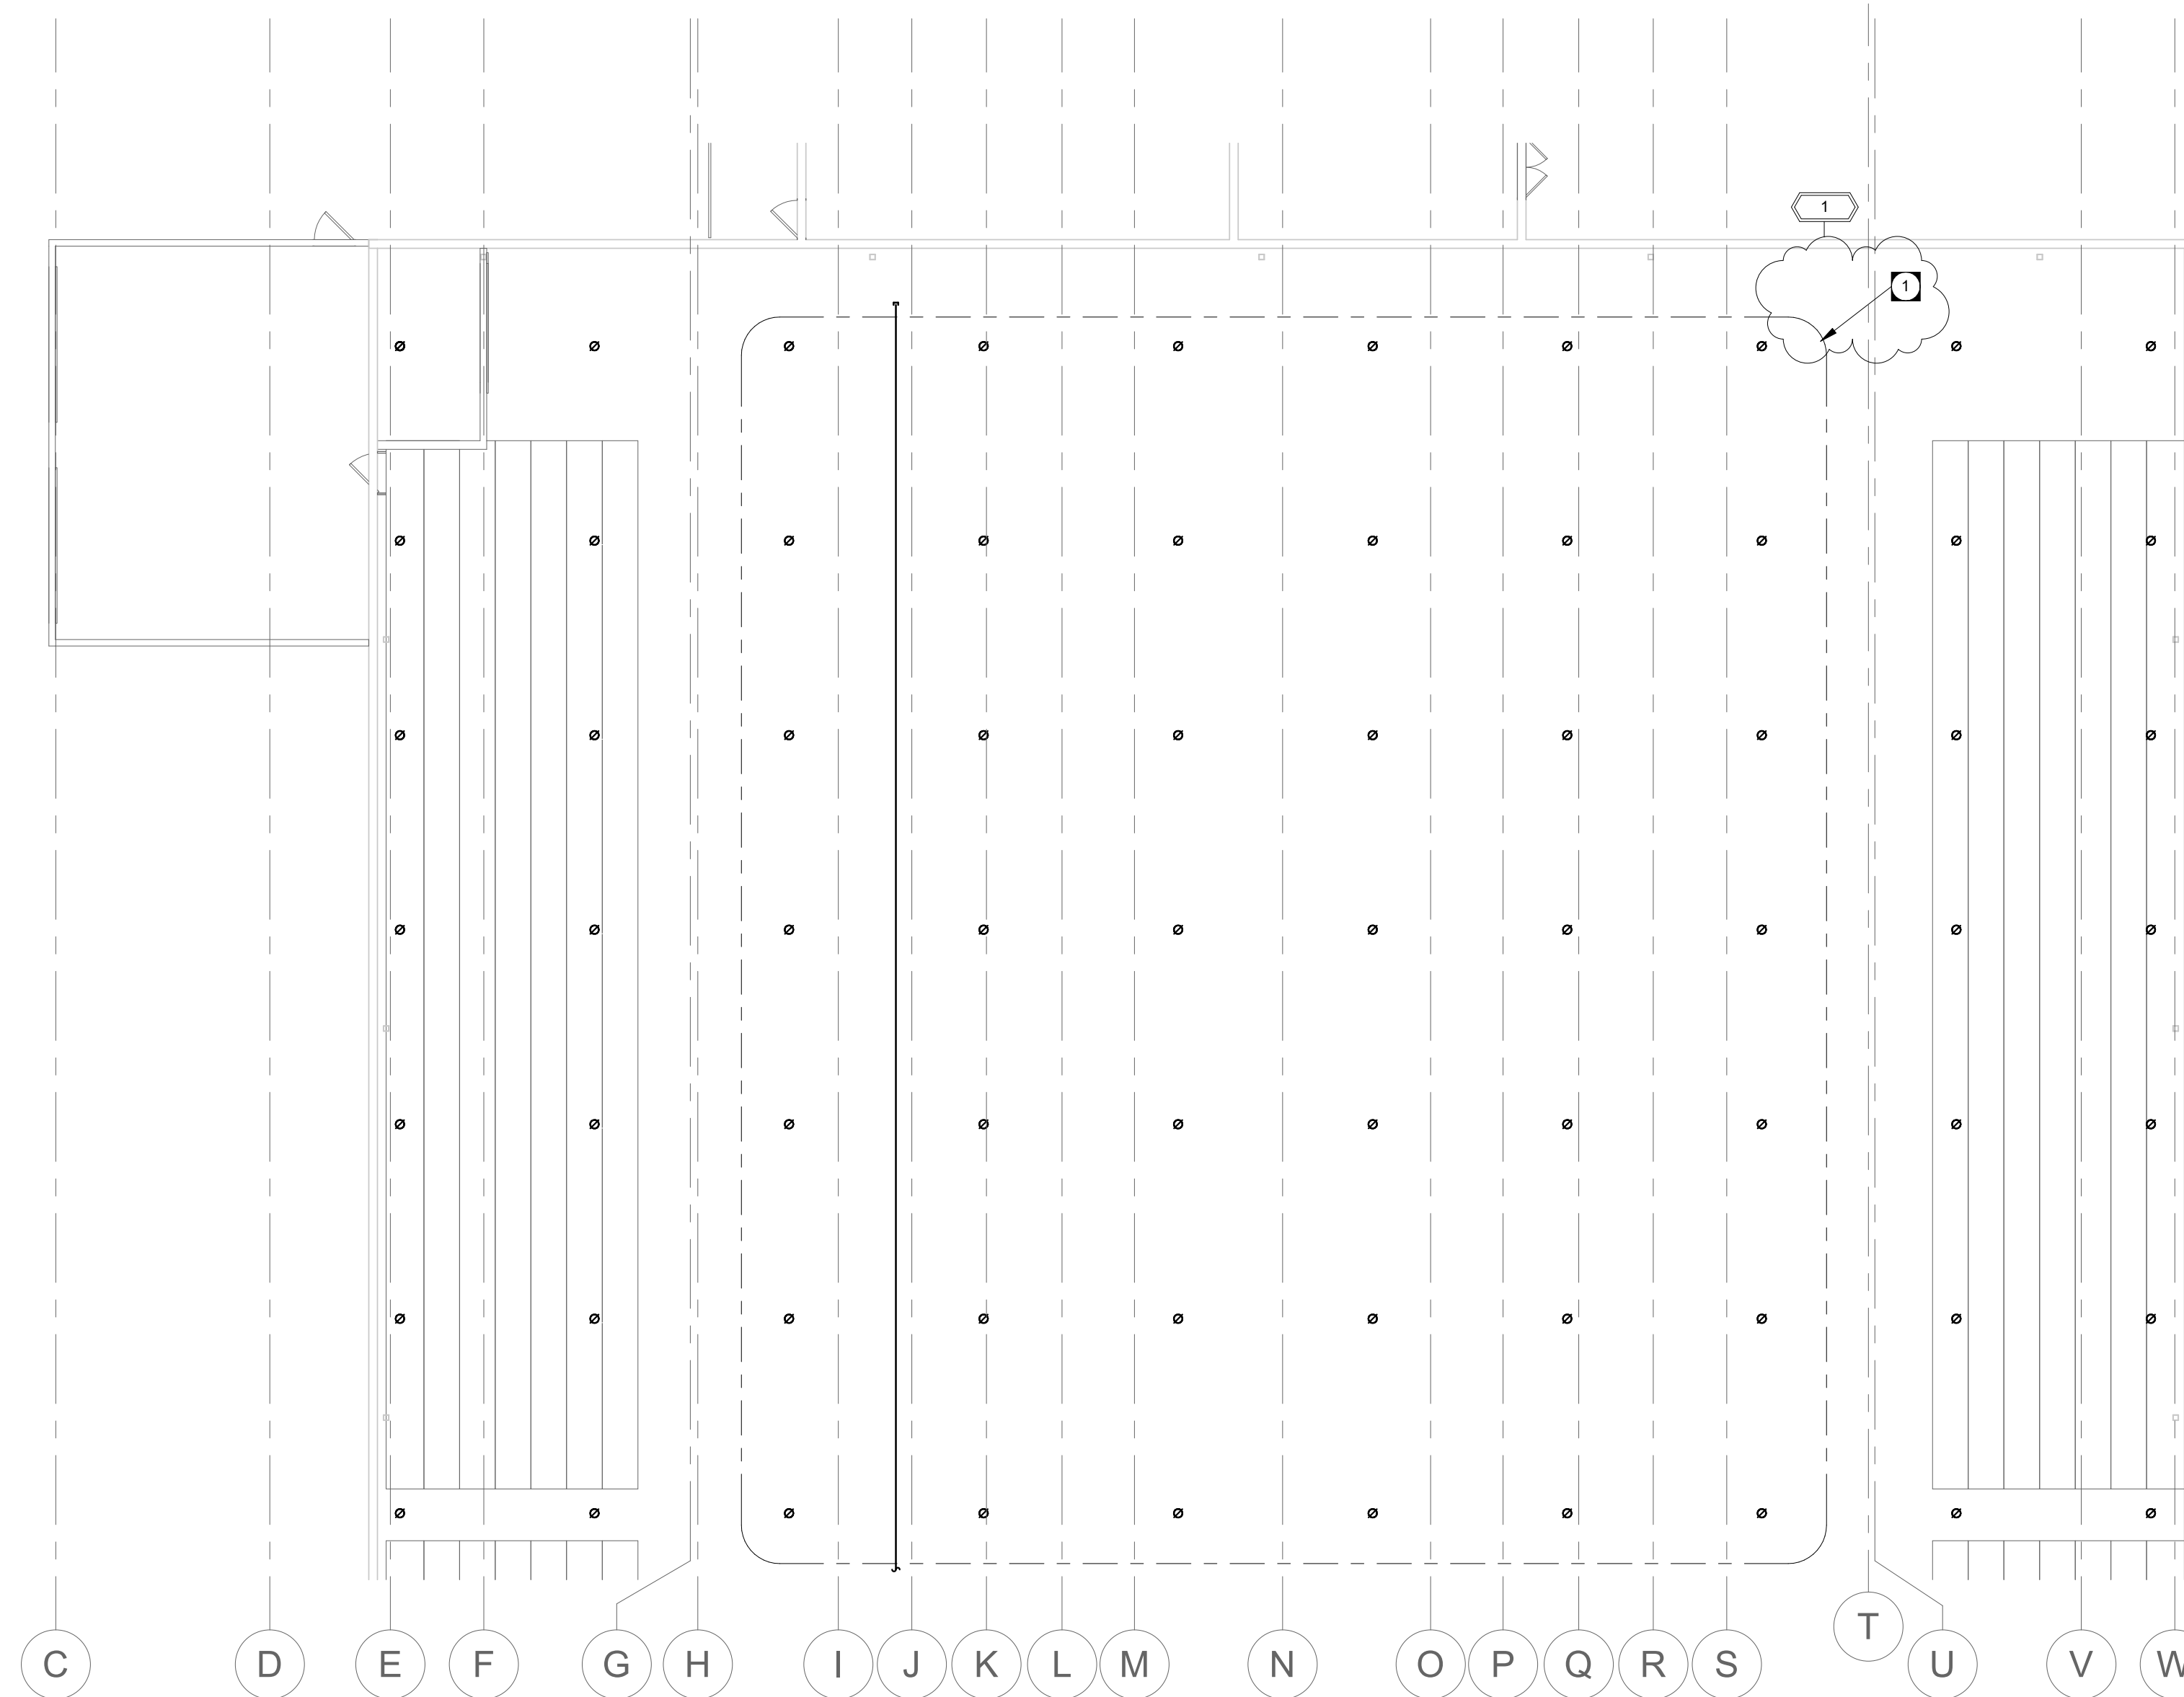

**APEGM**  
 Certificate of Authorization  
 Epp Siepmann Engineering Inc.  
 No. 4035

This is a print of a document that has been electronically authenticated with technology authorized by the APEGM. The original is in electronic form.

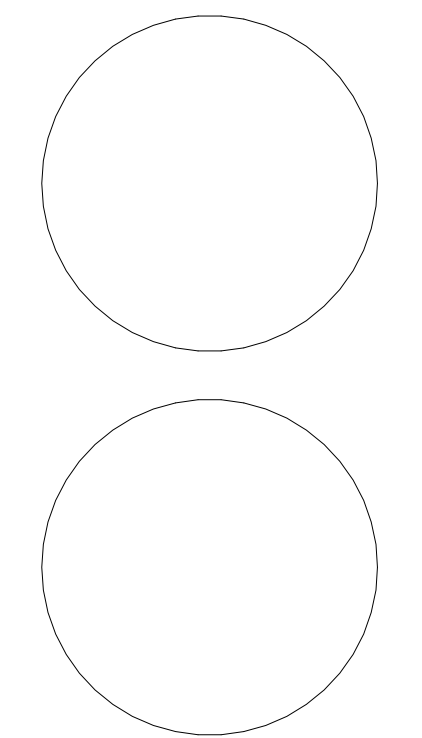

ARENA NORTH HIGH LEVEL - FIRE PROTECTION RENOVATION 1  
 3/32" = 1'-0" MF2.4-R1

This drawing must not be scaled. The contractors shall verify all dimensions and other data on site prior to commencement of work. Discrepancies, errors, and omissions are to be reported to Public City Architecture Inc. prior to proceeding with the Work.

Drawings and specifications as instruments of service are the property of Public City Architecture Inc. the copyright in the same being reserved.

No reproduction or revision to these drawings may be made without the permission of Public City Architecture Inc. and when made, must bear their name. All prints to be returned to Public City Architecture Inc. upon request.

Project  
 ST. JAMES CIVIC CENTRE

Drawing  
 ARENA NORTH - FIRE PROTECTION PLAN

Drawn By: Review By:  
 GC JS  
 Scale: Tender No:  
 3/32" = 1'-0" 1176-2019  
 Date: 11/06/19  
 Sheet:

MF2.4-R1