



NOTE
FOR LOCATION OF FORCE MAIN
THROUGH BLDG. WALL SEE DWG. M-2


WESTWOOD DRIVE PUMPING STATION
SITE PLAN
1" = 50'

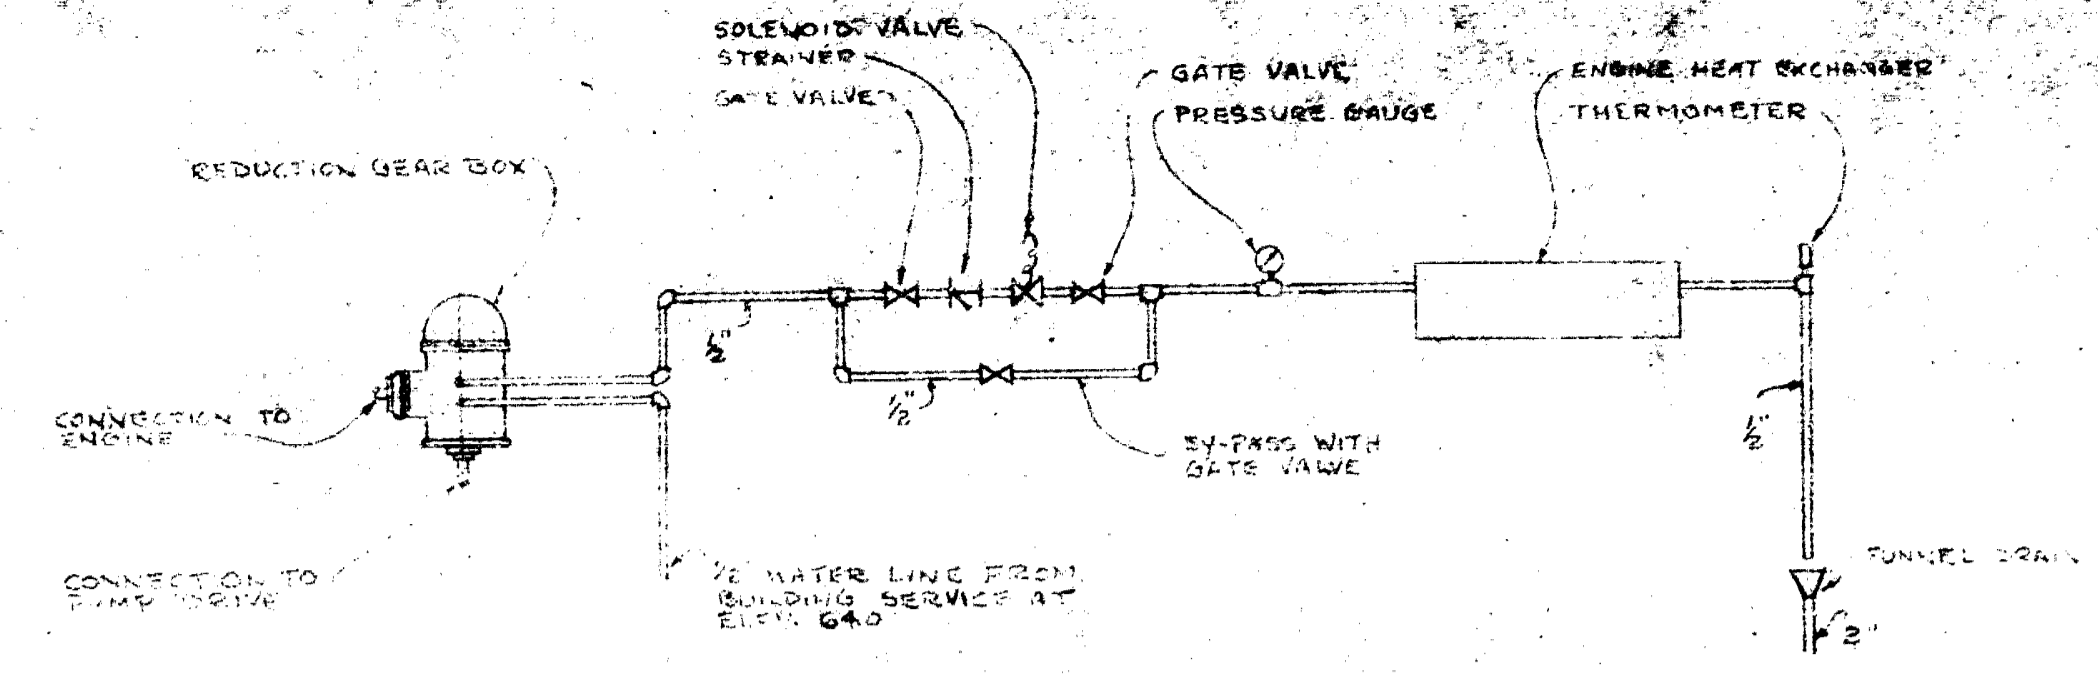

SCHEMATIC DIAGRAM OF CONNECTION TO REDUCTION GEAR BOX & ENGINE N.T.S.

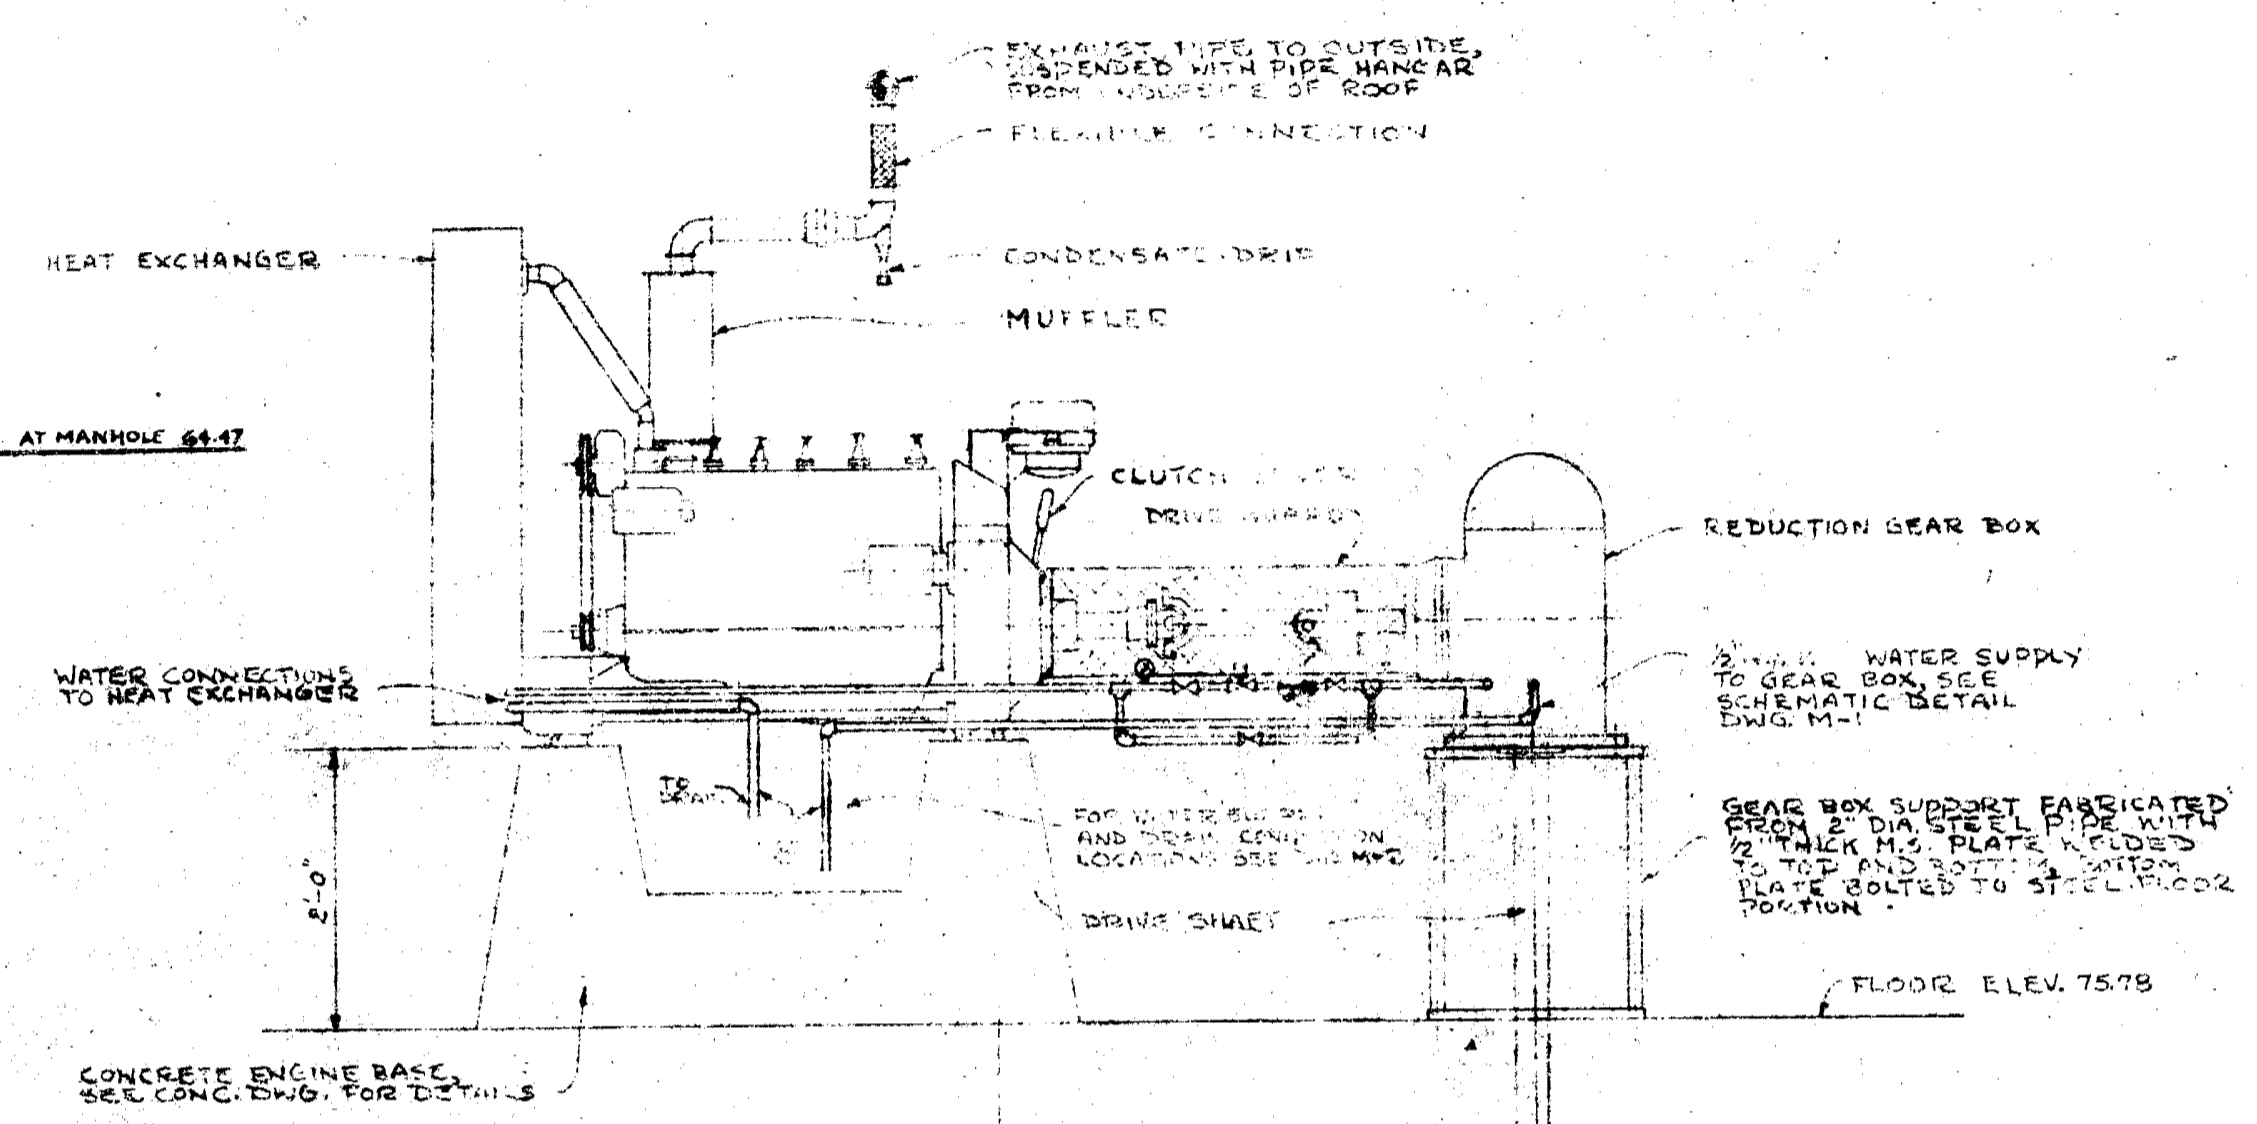

DETAIL OF ENGINE & REDUCTION GEAR BOX N.T.S.

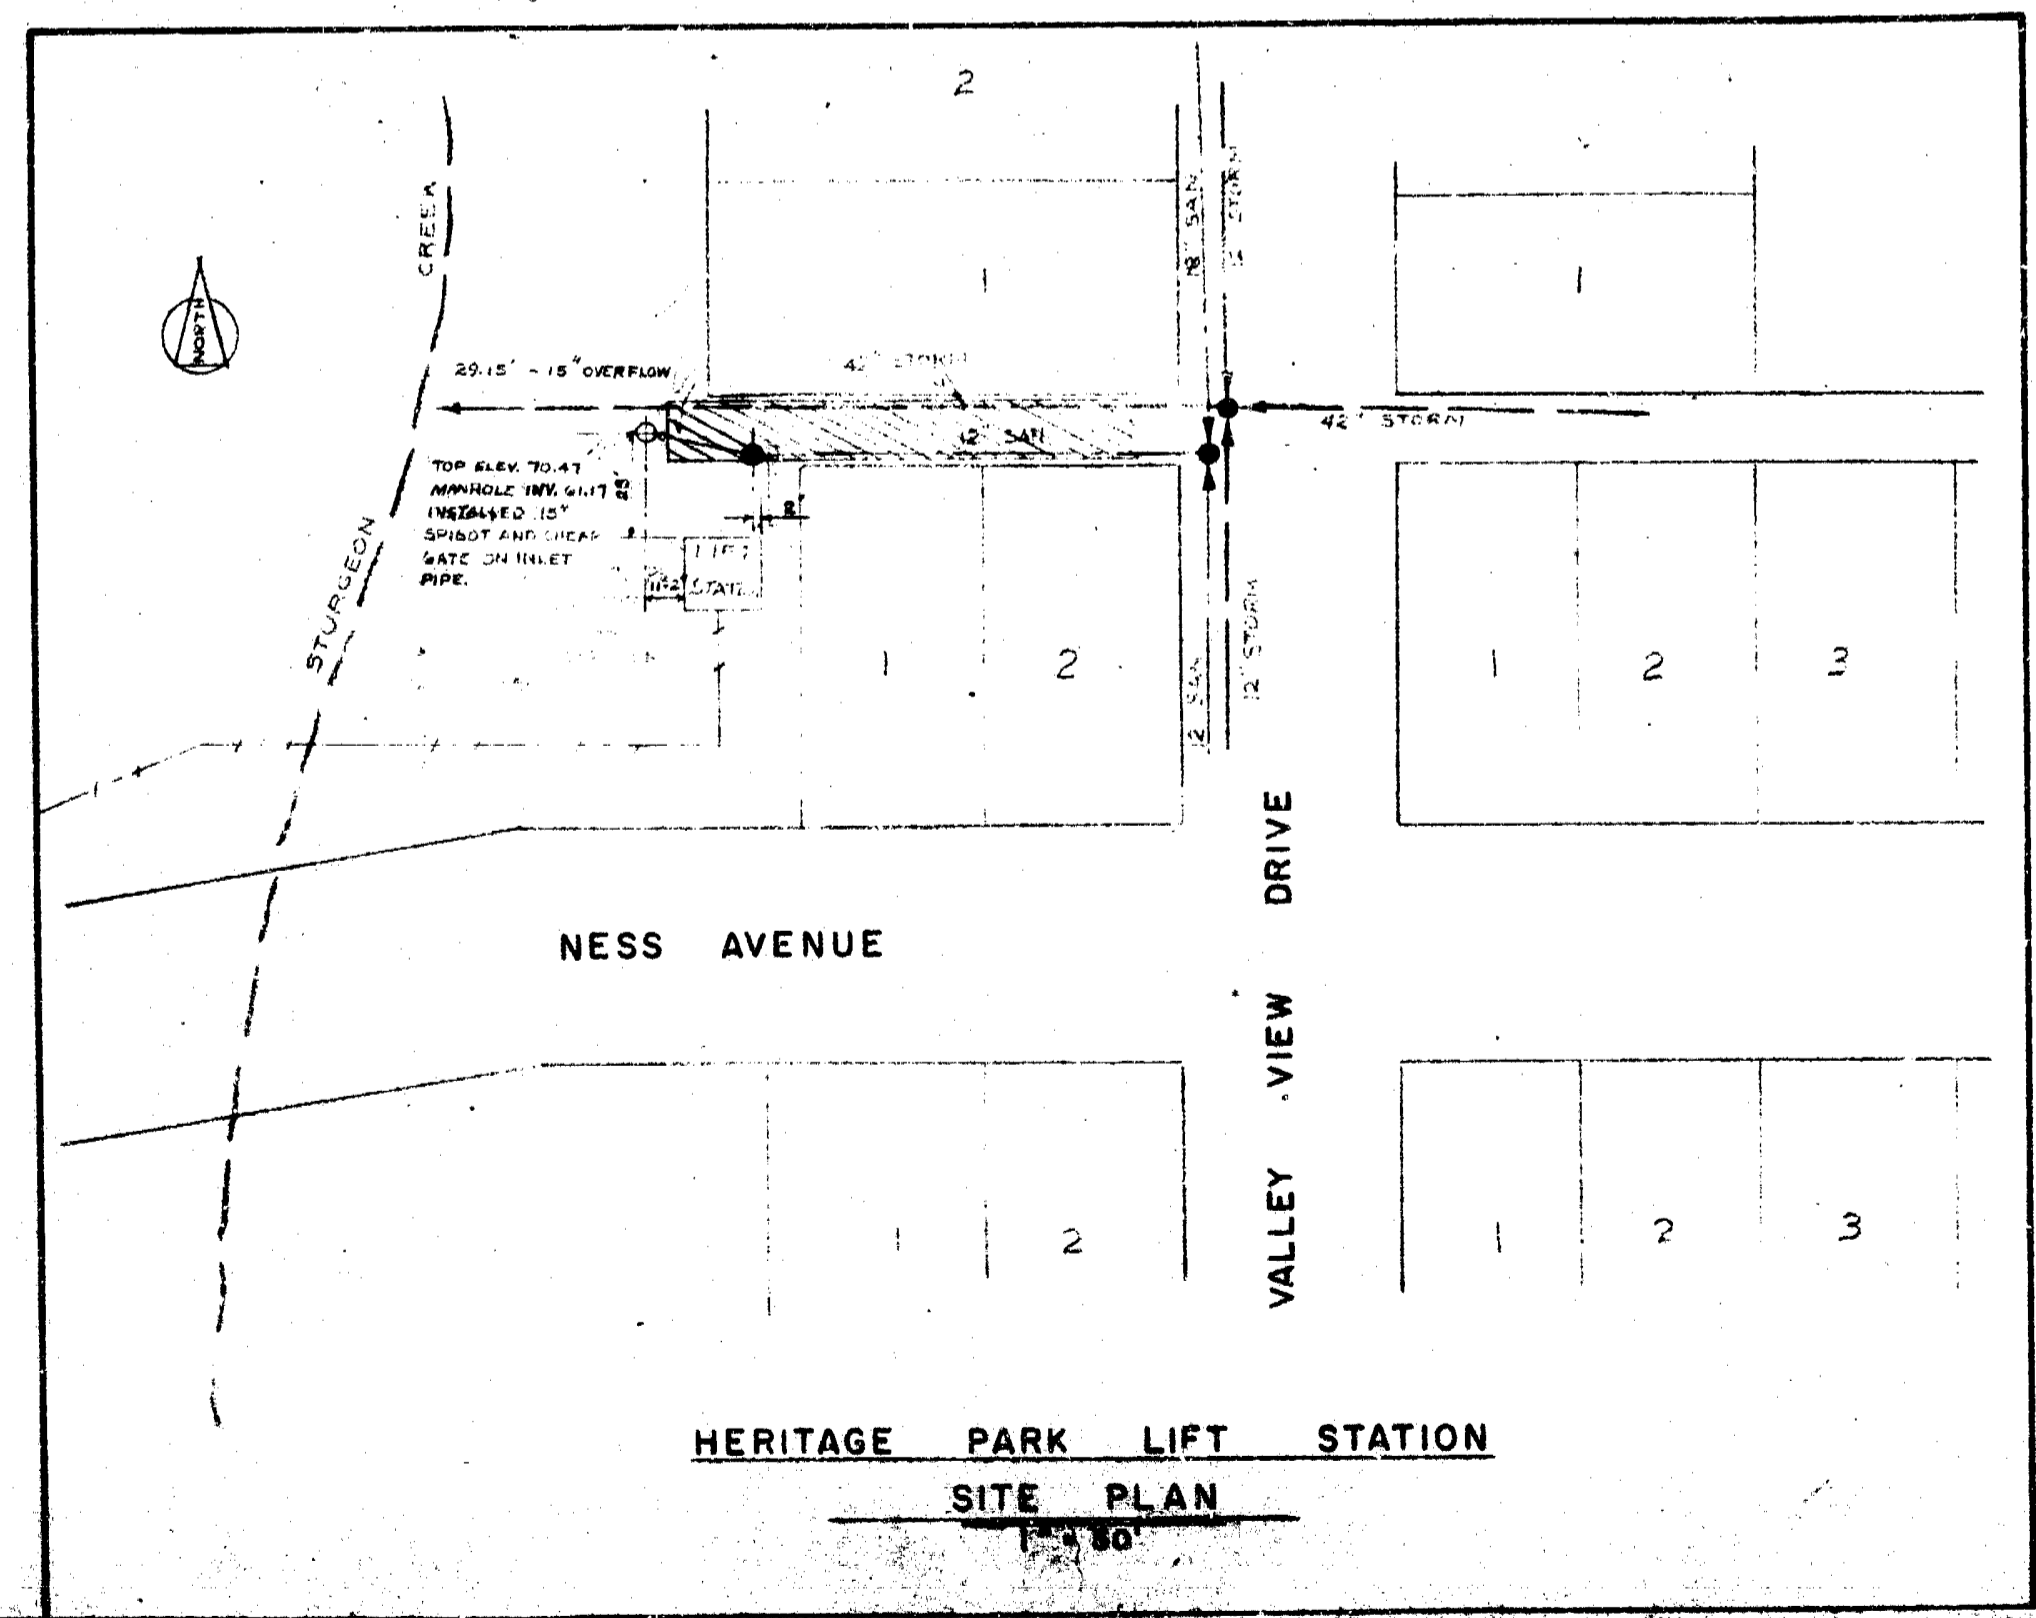

HERITAGE PARK LIFT STATION
SITE PLAN
1" = 50'

NO.	DESCRIPTION	DATE	BY
REVISIONS			

APPROVED BY: _____ DATE: _____
MUNICIPALITY OF ASSINIBOIA
 WESTWOOD DR. SEWAGE PUMPING STATION
 AS BUILT
 MECHANICAL
 SITE PLAN & DETAILS

UNDERWOOD McLELLAN & ASSOCIATES
 LIMITED
 CONSULTING PROFESSIONAL ENGINEERS
 MANITOBA SASKATCHEWAN ALBERTA BRITISH COLUMBIA

DRAWN BY E. B.	DESIGNED BY
CHECKED BY	CHECKED BY
DATE DRAWN NOV. 25, 1968.	SCALE NOTED
JOB NO. 41-02-063-98-01	DRAWING NO.
SHEET 1 OF 6	AB M-1