




1 PLAN SECTION

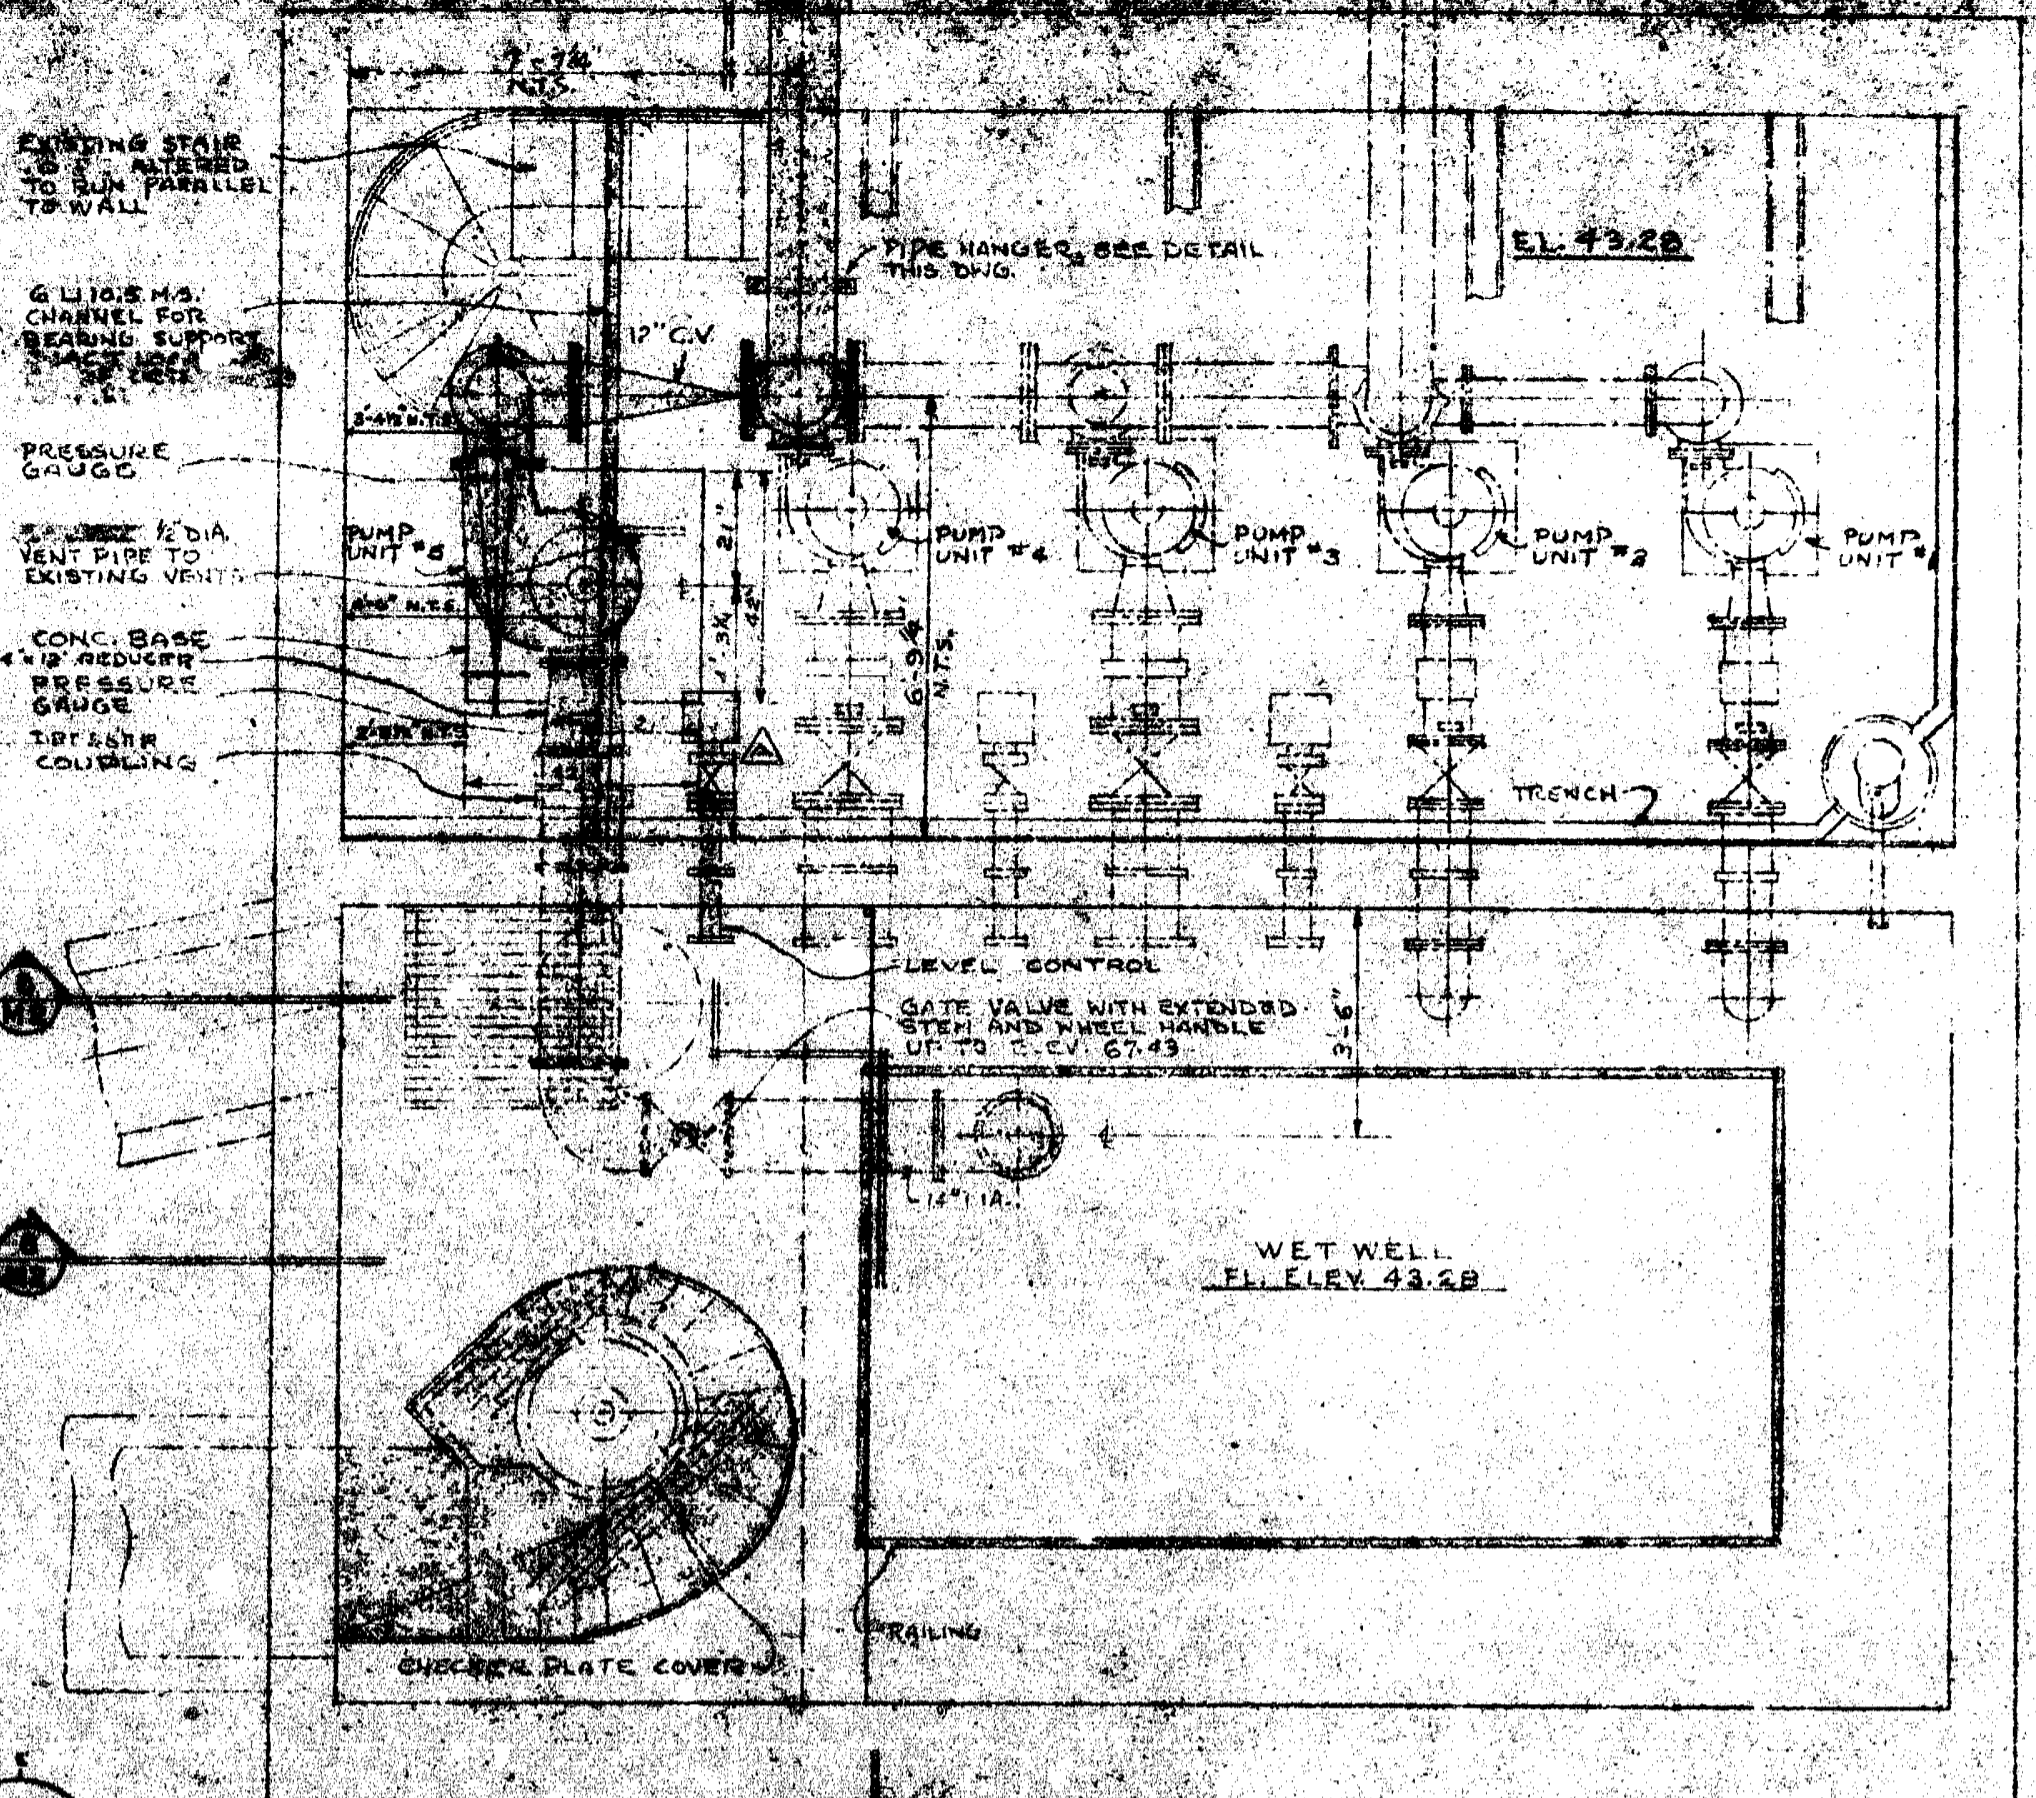


3 PLAN SECTION

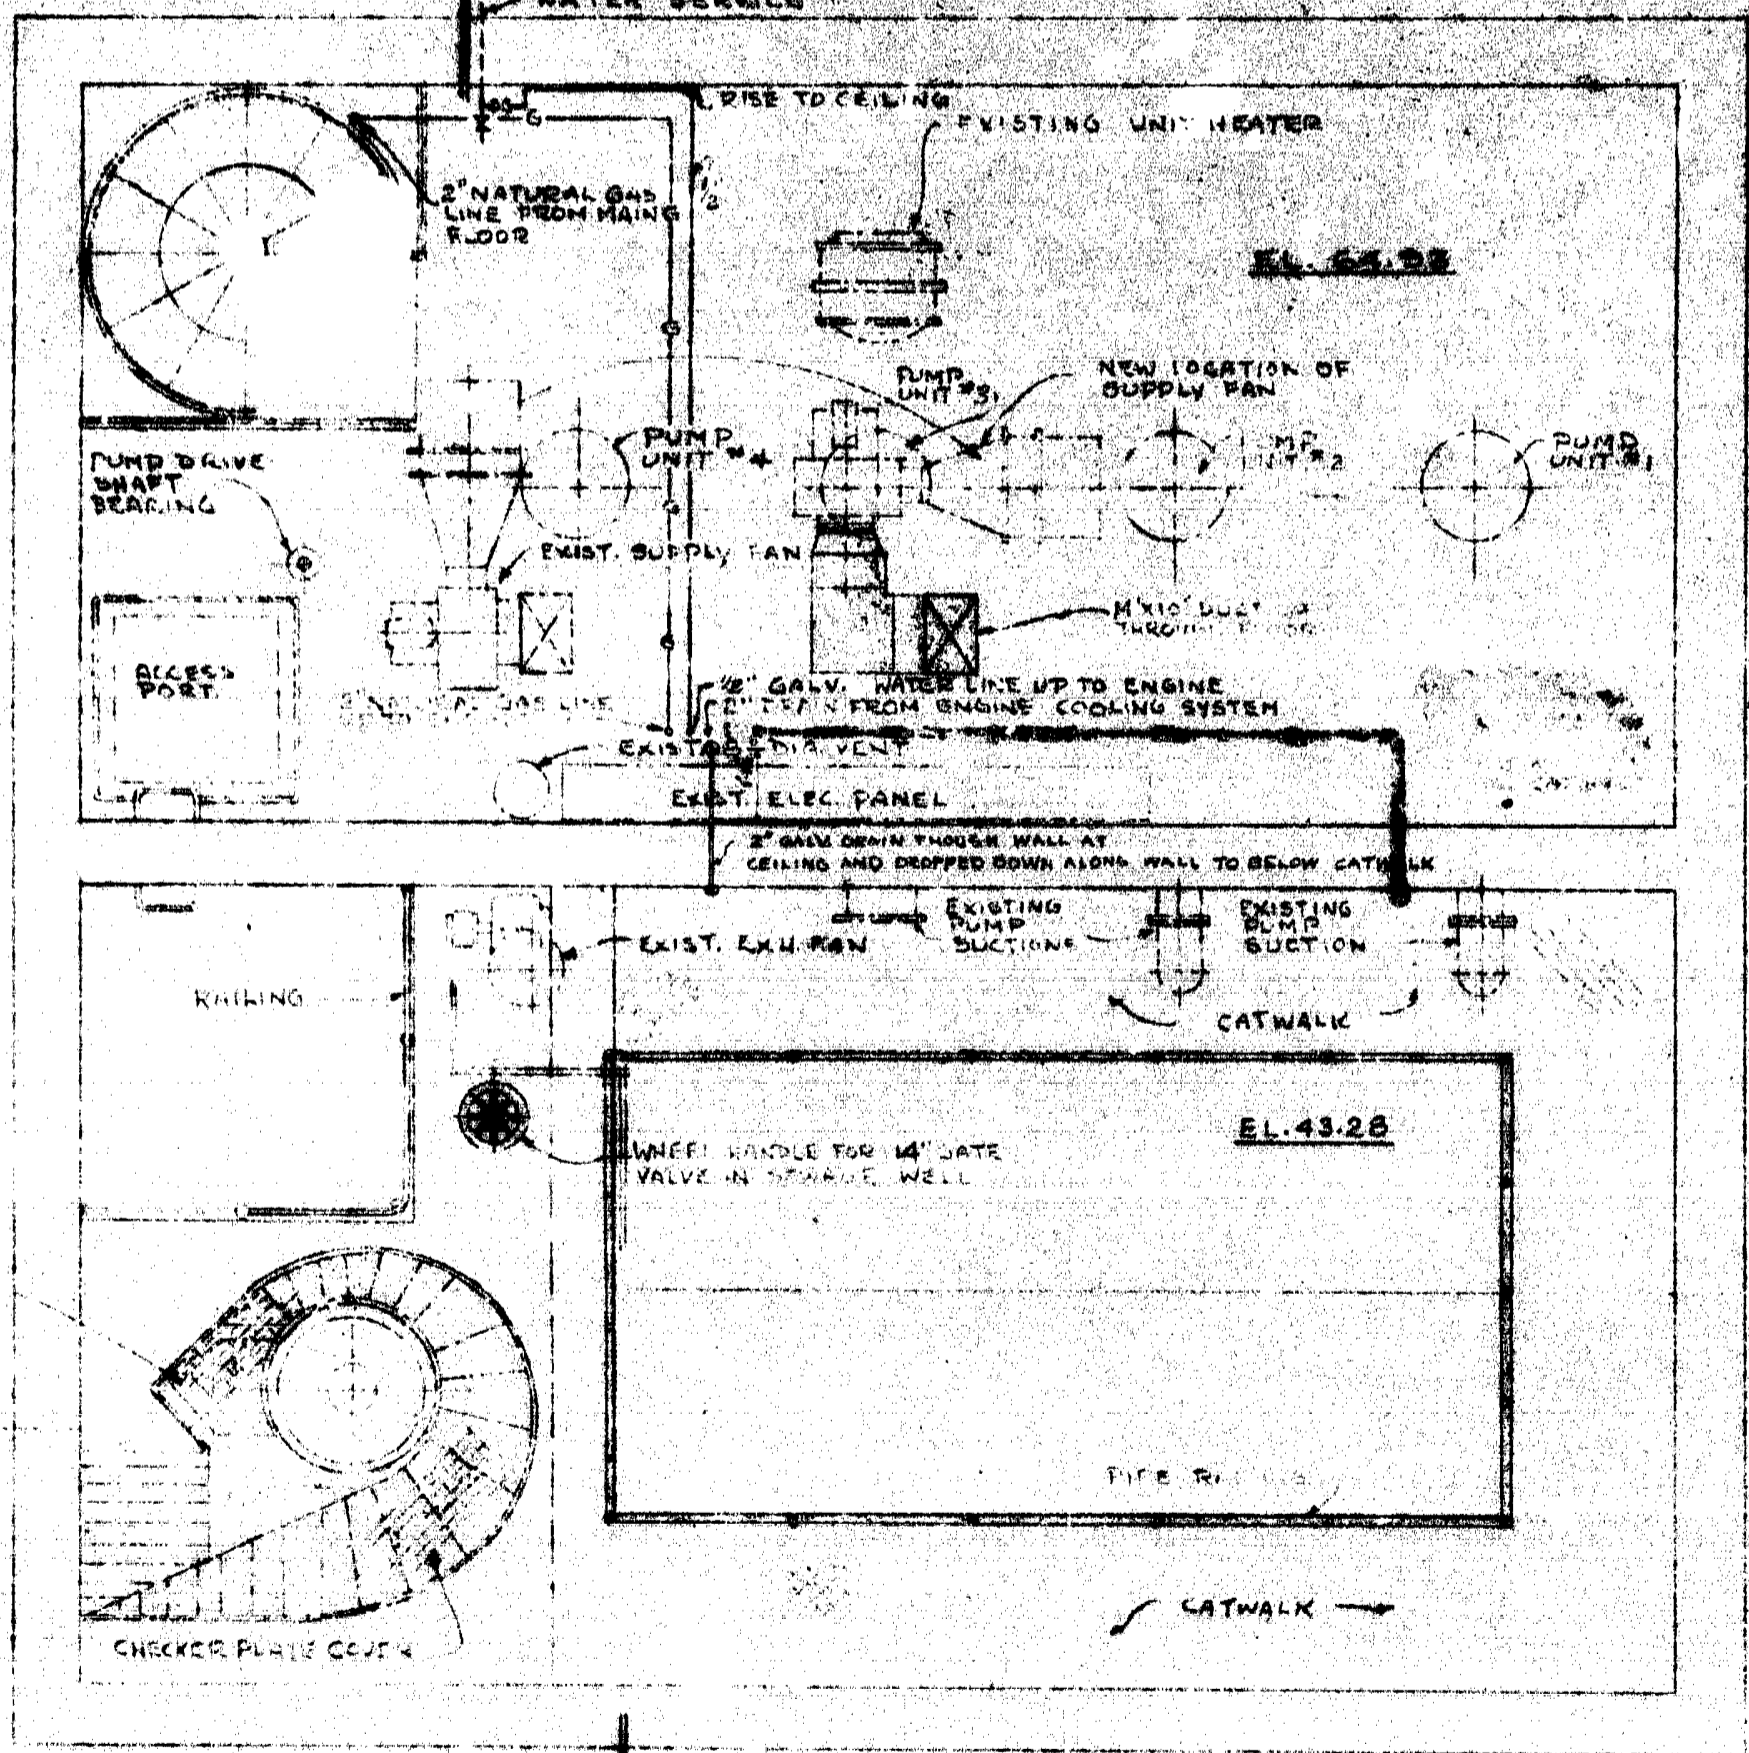


2 PLAN SECTION

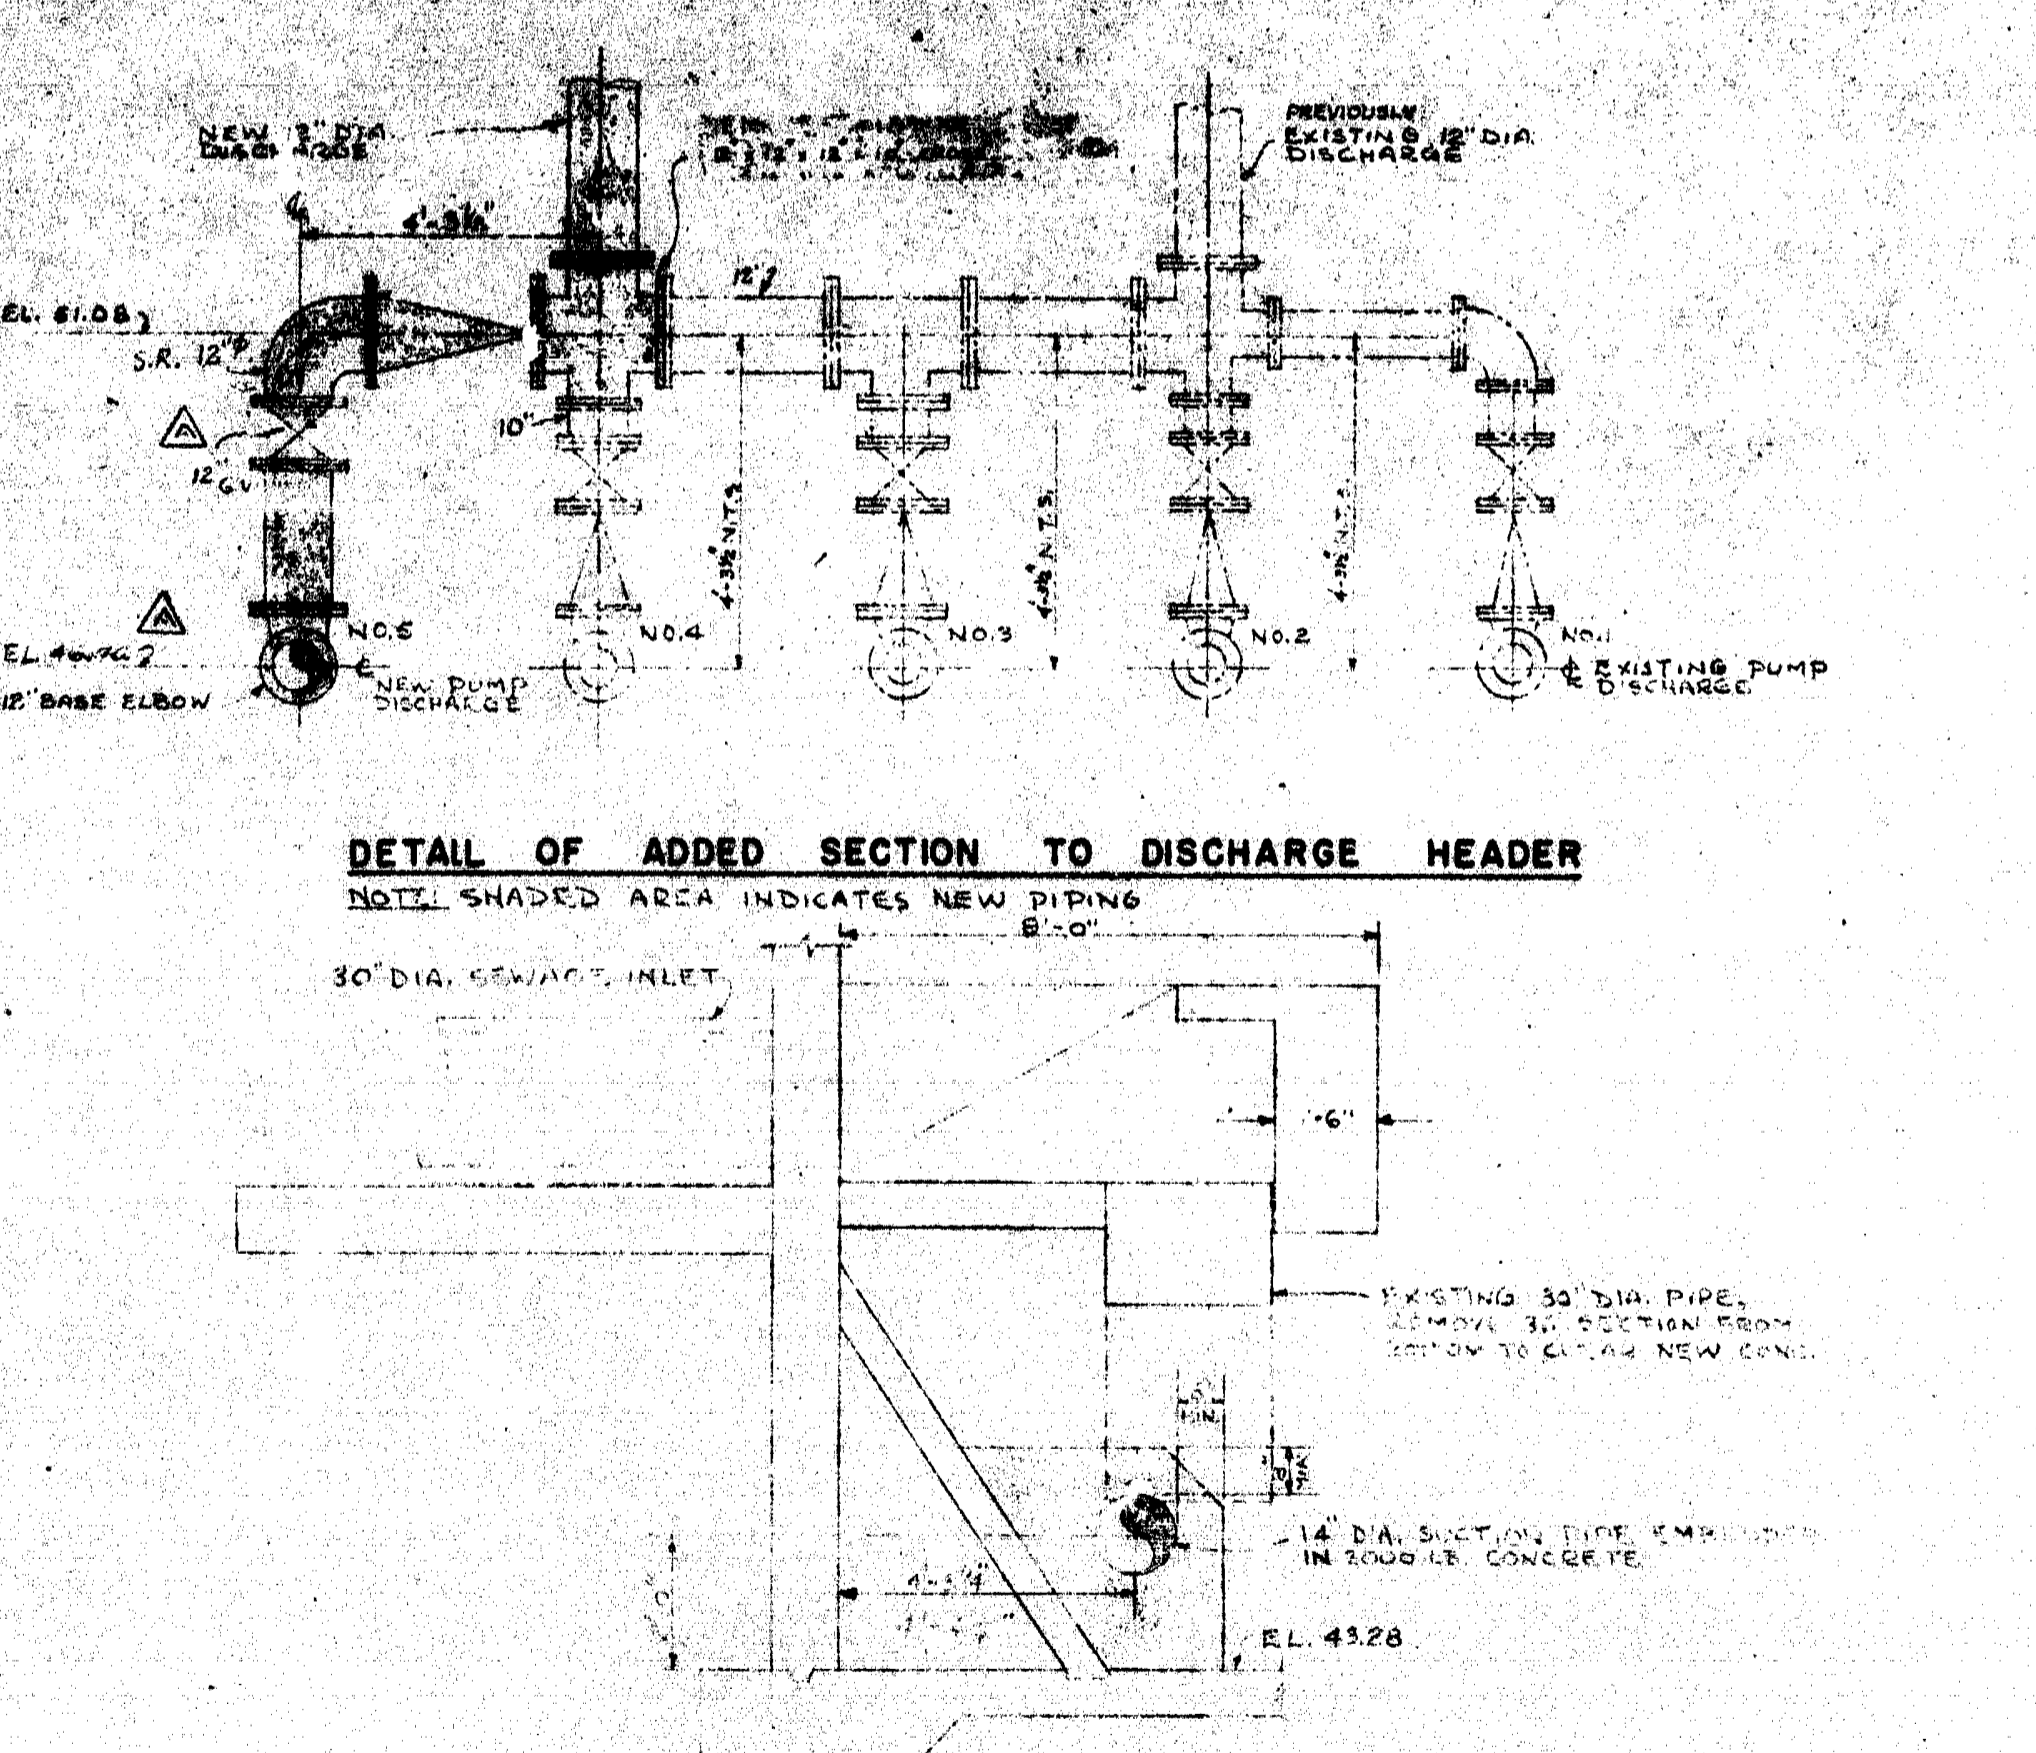

5 SECTION

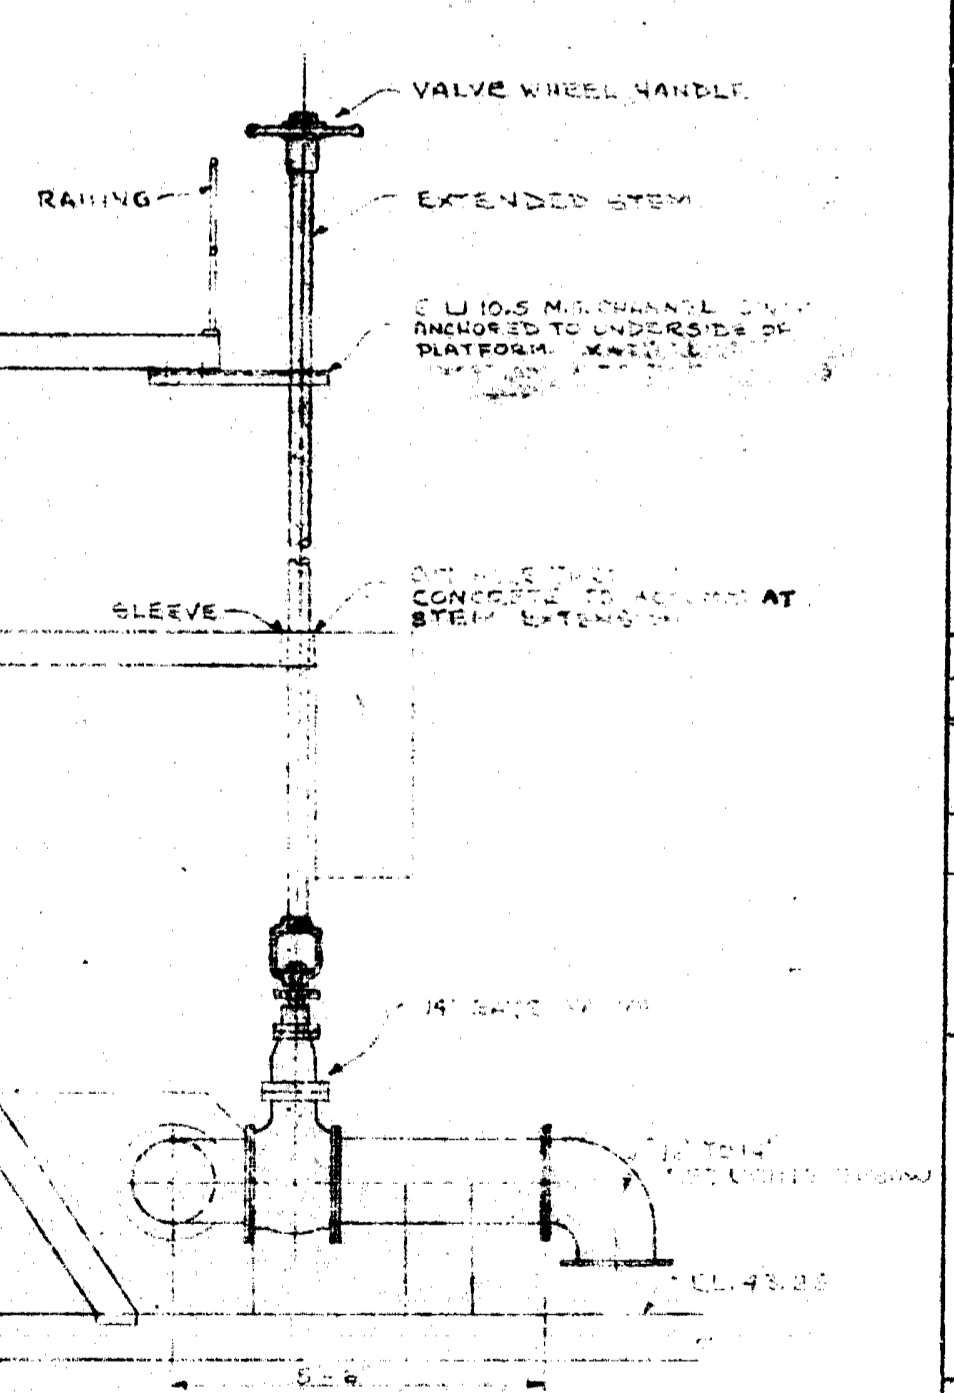

6 SECTION

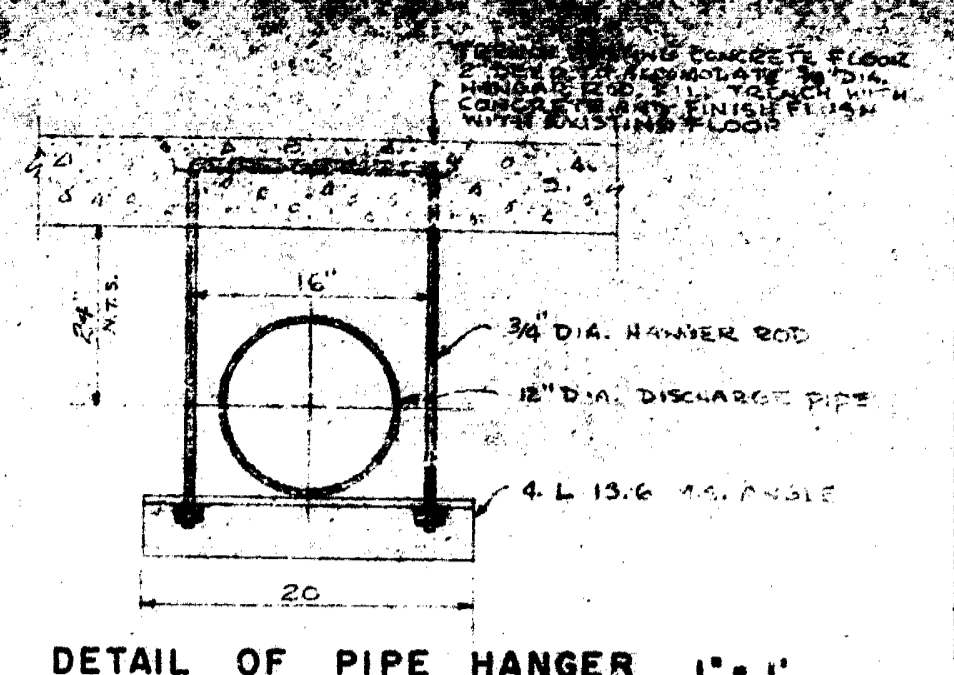

NOTE: ALL MISCELLANEOUS METAL SUCH AS RODS, ANGLES ETC. TO BE GALVANIZED

NO.	DESCRIPTION	DATE	BY
REVISIONS			
APPROVED BY		DATE	
MUNICIPALITY OF ASSINIBOIA			
WESTWOOD DR. SEWAGE PUMPING STATION			
AS BUILT MECHANICAL PLANS & DETAILS			
UNDERWOOD McLELLAN & ASSOCIATES LIMITED			
CONSULTING PROFESSIONAL ENGINEERS			
MANITOBA SASKATCHEWAN ALBERTA BRITISH COLUMBIA			
DRAWN BY	E. B.	DESIGNED BY	
CHECKED BY		CHECKED BY	
DATE DRAWN	NOV. 25, 1968.	SCALE	3/8" = 1"
JOB NO.	41-02-063-93-01	DRAWING NO.	
SHEET	2 OF 6	AB	M-2