




1 WALL SECTION SCALE 1:10

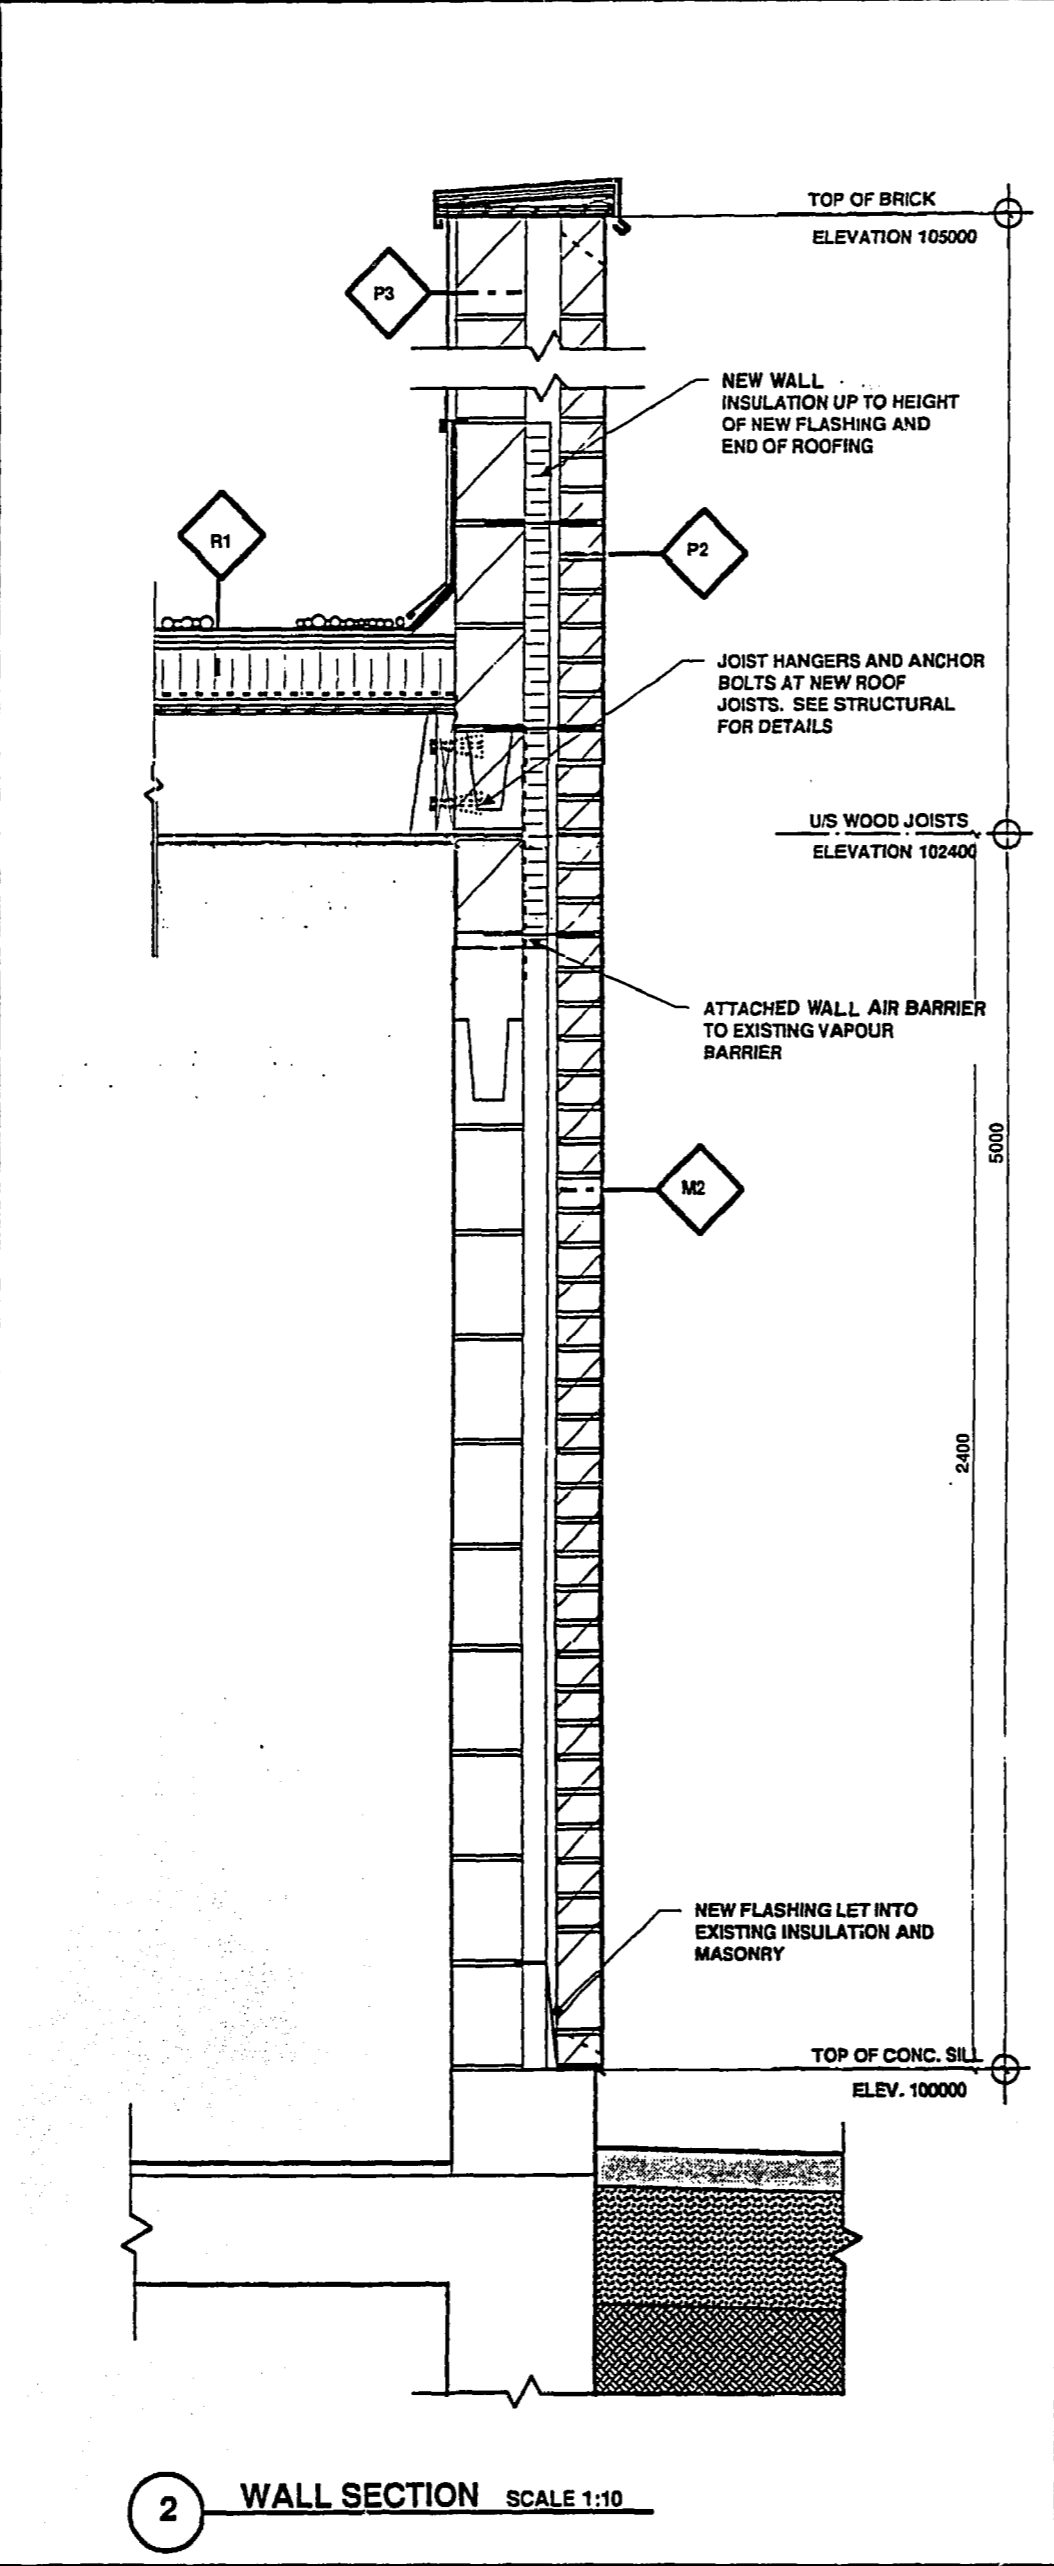


2 WALL SECTION SCALE 1:10

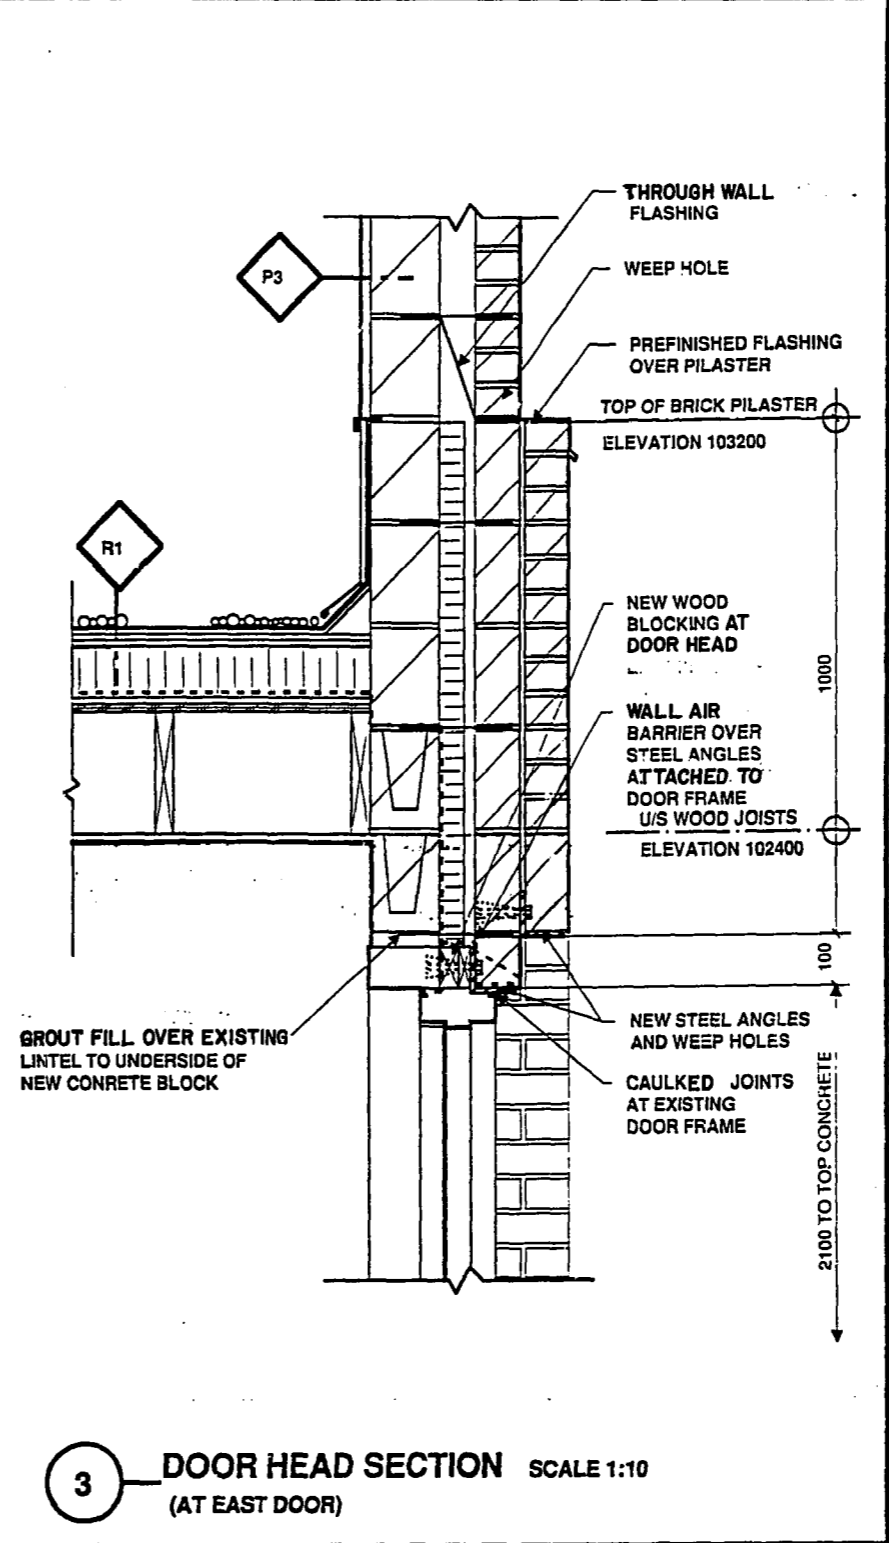


3 DOOR HEAD SECTION SCALE 1:10 (AT EAST DOOR)

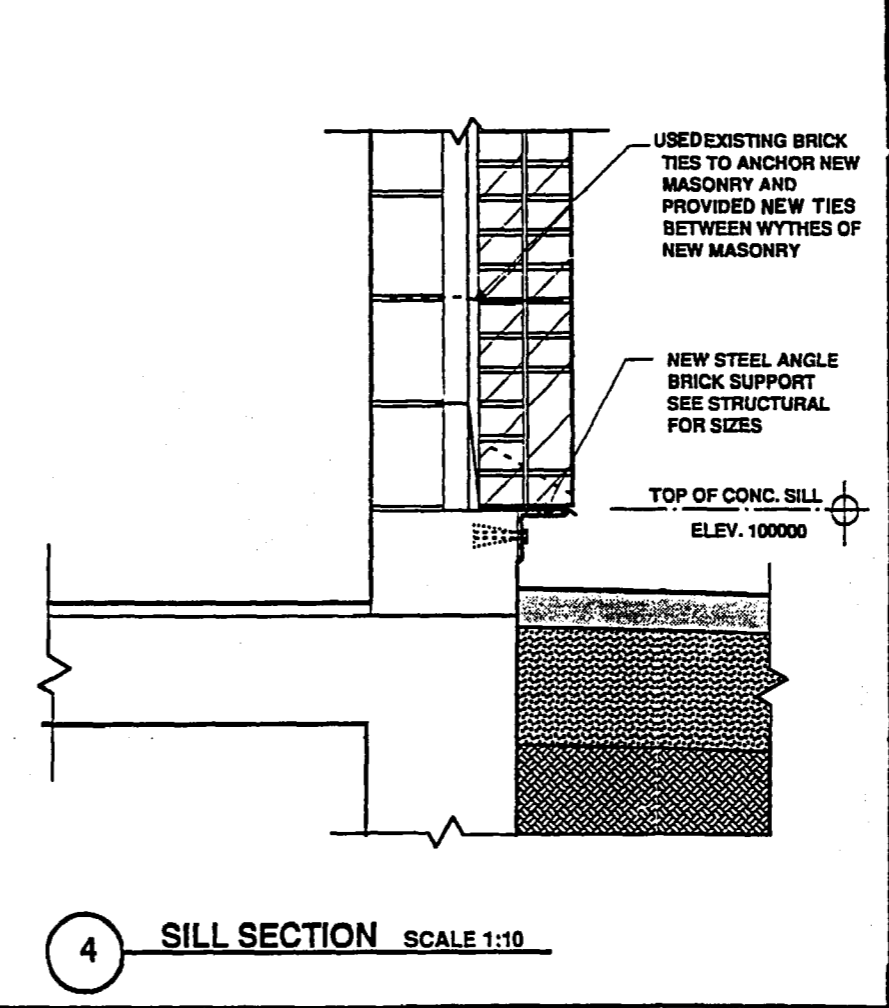

4 SILL SECTION SCALE 1:10

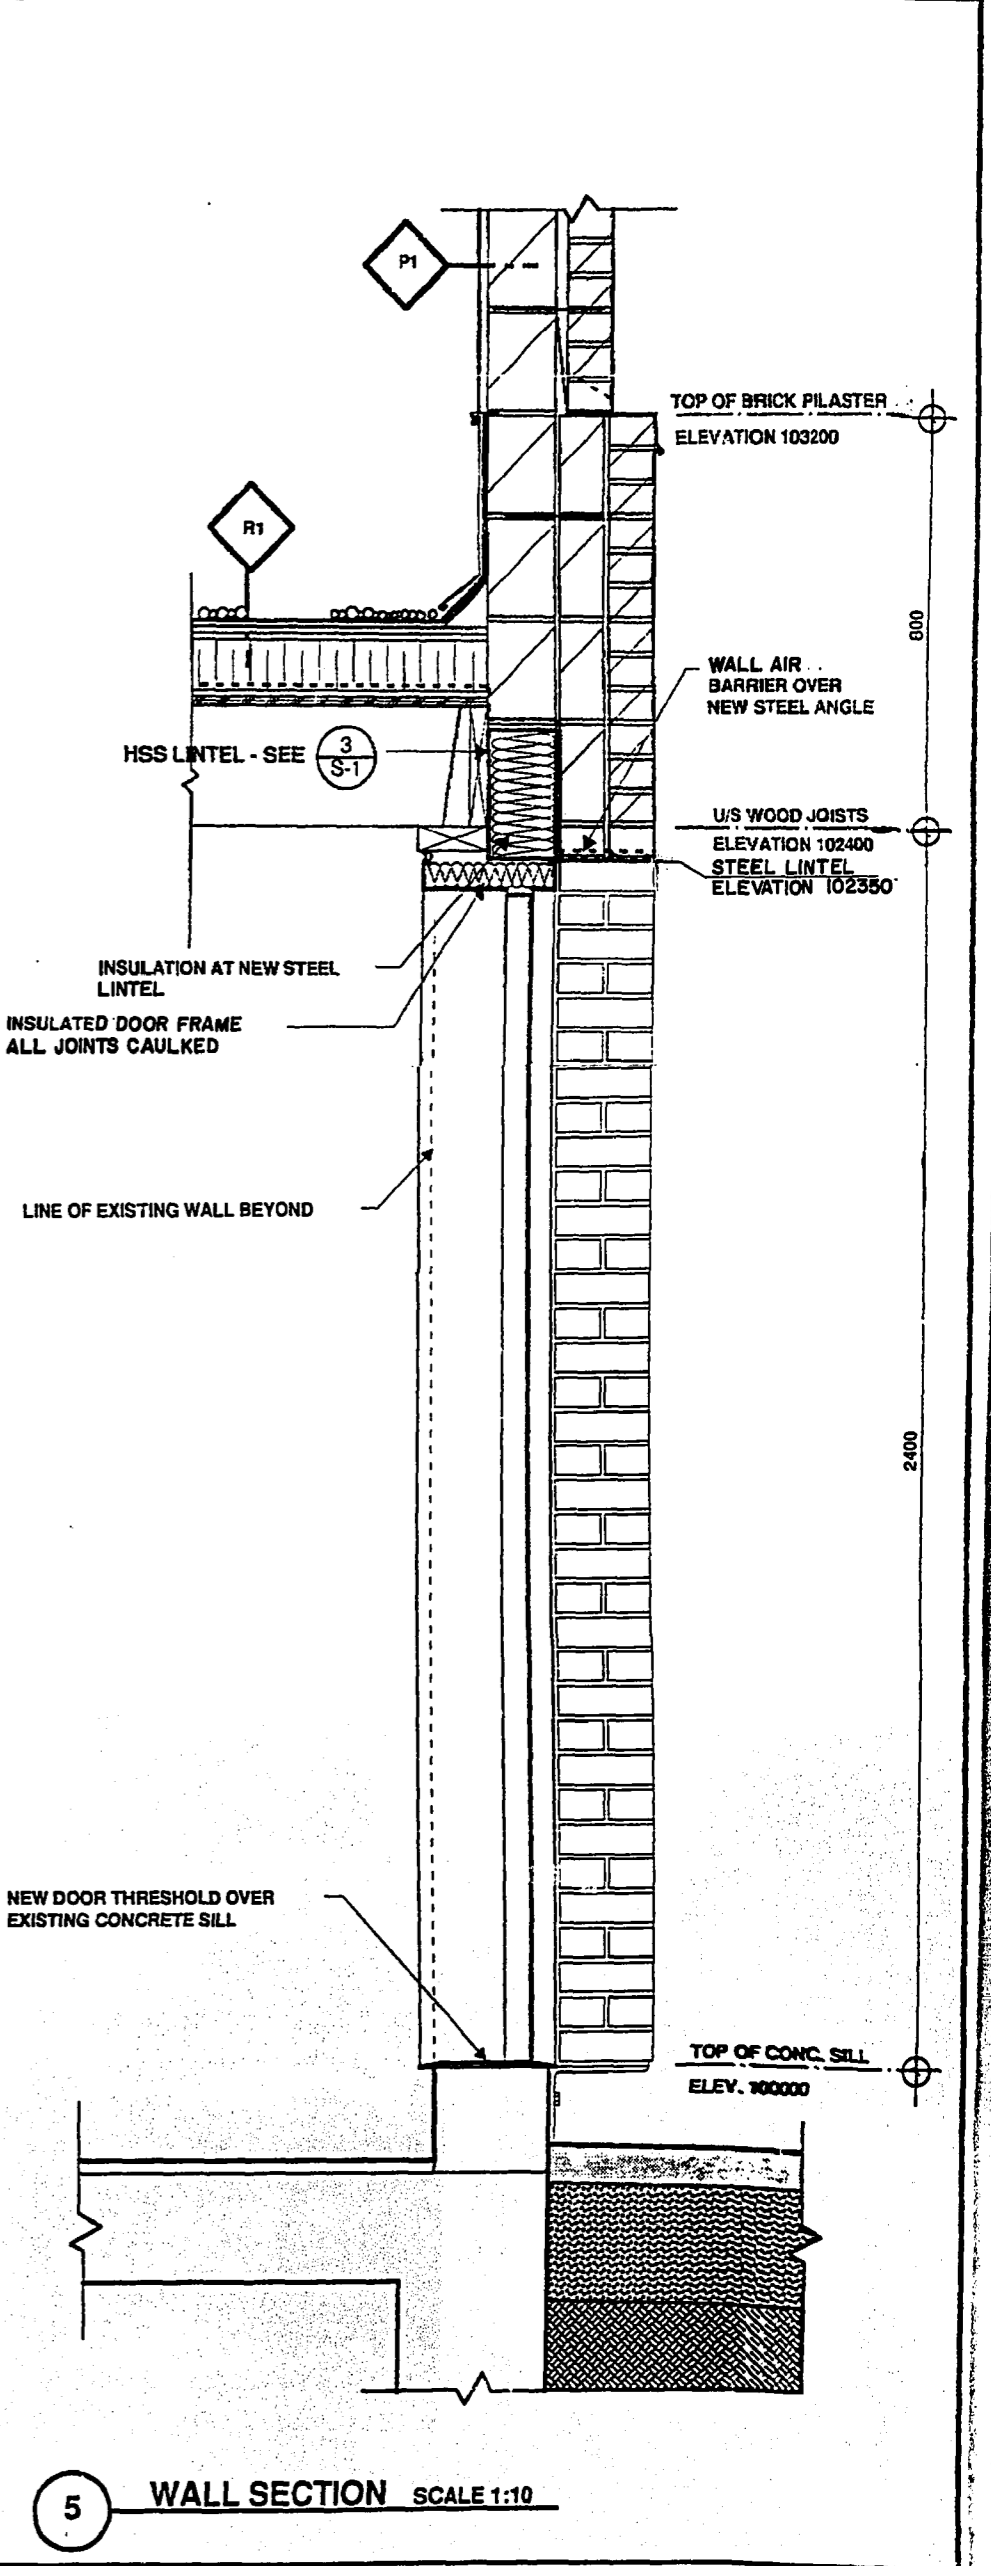

5 WALL SECTION SCALE 1:10

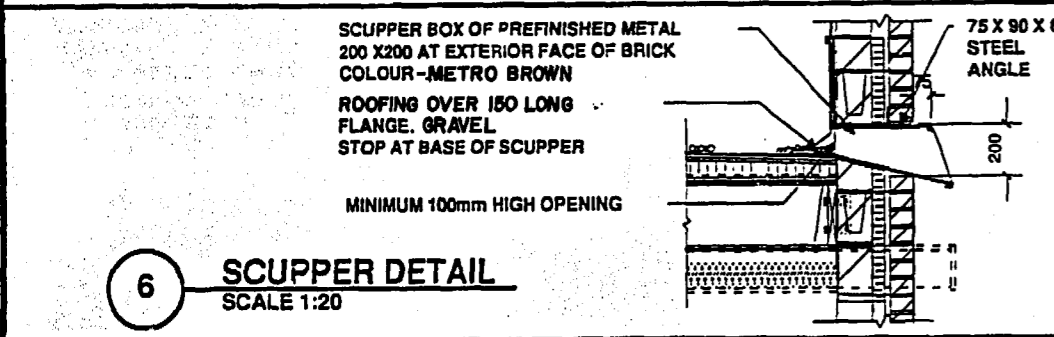

6 SCUPPER DETAIL SCALE 1:20

**AS-CONSTRUCTED**  
 Inspection Survey Technical Services  
 WATERWORKS, WASTE & DISPOSAL DEPARTMENT  
 Date: 93.10.08

B. M. ELEV.	
DESIGNED BY	TPLL
CHECKED BY	<i>[Signature]</i>
DRAWN BY	PB
APPROVED BY	<i>[Signature]</i>
HOR. SCALE:	AS NOTED
VERTICAL:	
REVISIONS	
1 REVISED AS-BUILT	93.09 WKT
NO. REVISIONS	DATE BY

**Thomas Llewelin Architect Inc.**  
 CONSULTANT DRAWING NO. 9101-A3



**THE CITY OF WINNIPEG**  
 WORKS AND OPERATIONS DIVISION  
 WATERWORKS WASTE AND DISPOSAL DEPARTMENT

**WESTWOOD PUMPING STATION: ARCHITECTURAL IMPROVEMENTS**

WALL SECTIONS, DETAILS

CITY DRAWING NO. 1349  
 SHEET 3 OF 4  
**9101-A3**