

NOTES


1. Drawings Not to Scale (NTS);

LEGEND



KEYNOTE LEGEND

- |                     |                           |
|---------------------|---------------------------|
| 1. CORE SAMPLE      | 24. DOWN SPOUT            |
| 2. CHIMNEY          | 25. BACK SLOPE            |
| 3. A/C UNIT         | 26. CANT                  |
| 4. SIGN SUPPORT     | 27. SLOPE TO DRAIN        |
| 5. VENTILATOR       | 28. CRICKET               |
| 6. VENT PIPE        | 29. PARAPET/WIDE FLASHING |
| 7. ROOF DRAIN       | 30. SAFETY LINE ANCHOR    |
| 8. SKYLIGHT         | 31. LIGHT POLES           |
| 9. EAVESTROUGH      | 32. GARAGE EXHAUST FAN    |
| 10. PLUMBING STACK  | 33. KITCHEN EXHAUST FAN   |
| 11. ANTENNA         |                           |
| 12. LADDER          |                           |
| 13. ATTIC VENT      |                           |
| 14. ROOF HATCH      |                           |
| 15. SCUPPER         |                           |
| 16. PITCH BOX       |                           |
| 17. HVAC UNIT       |                           |
| 18. CAPPED CURB     |                           |
| 19. FLAG POLE       |                           |
| 20. ELECTRICAL MAST |                           |
| 21. COOLING TOWER   |                           |
| 22. SPLASH PAD      |                           |
| 23. SPLASH PAN      |                           |

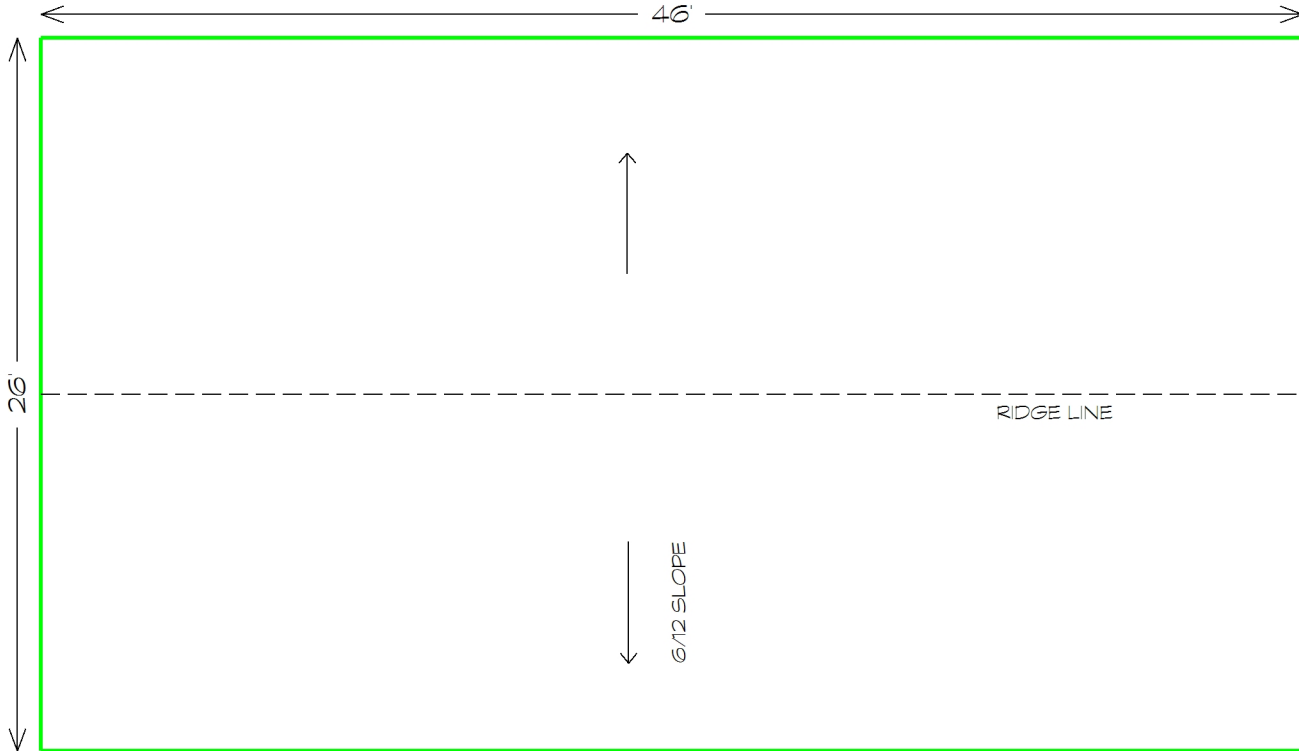

**GARAGE ROOF PLAN**



**QCA Building Envelope Ltd.**

1295 Pembina Highway Winnipeg, MB R3T 2B0  
Tel: (204) 371-0996

Project DEERLODGE COMMUNITY CENTRE  
323 BRUCE AVENUE WINNIPEG, MB R3J 2C3

Client City of Winnipeg

Dwg. No. AO-RO

Date Nov 10, 2018 Scale N.T.S.

This drawing is the property of QCA Building Envelope Ltd.  
It may not be reproduced without consent.