




# THE CITY OF WINNIPEG

## WATER AND WASTE DEPARTMENT

### NORTH END SEWAGE TREATMENT PLANT (NEWPCC)

# DIGESTER 11 ELECTRICAL AND AUTOMATION UPGRADES

BID OPPORTUNITY 630-2019

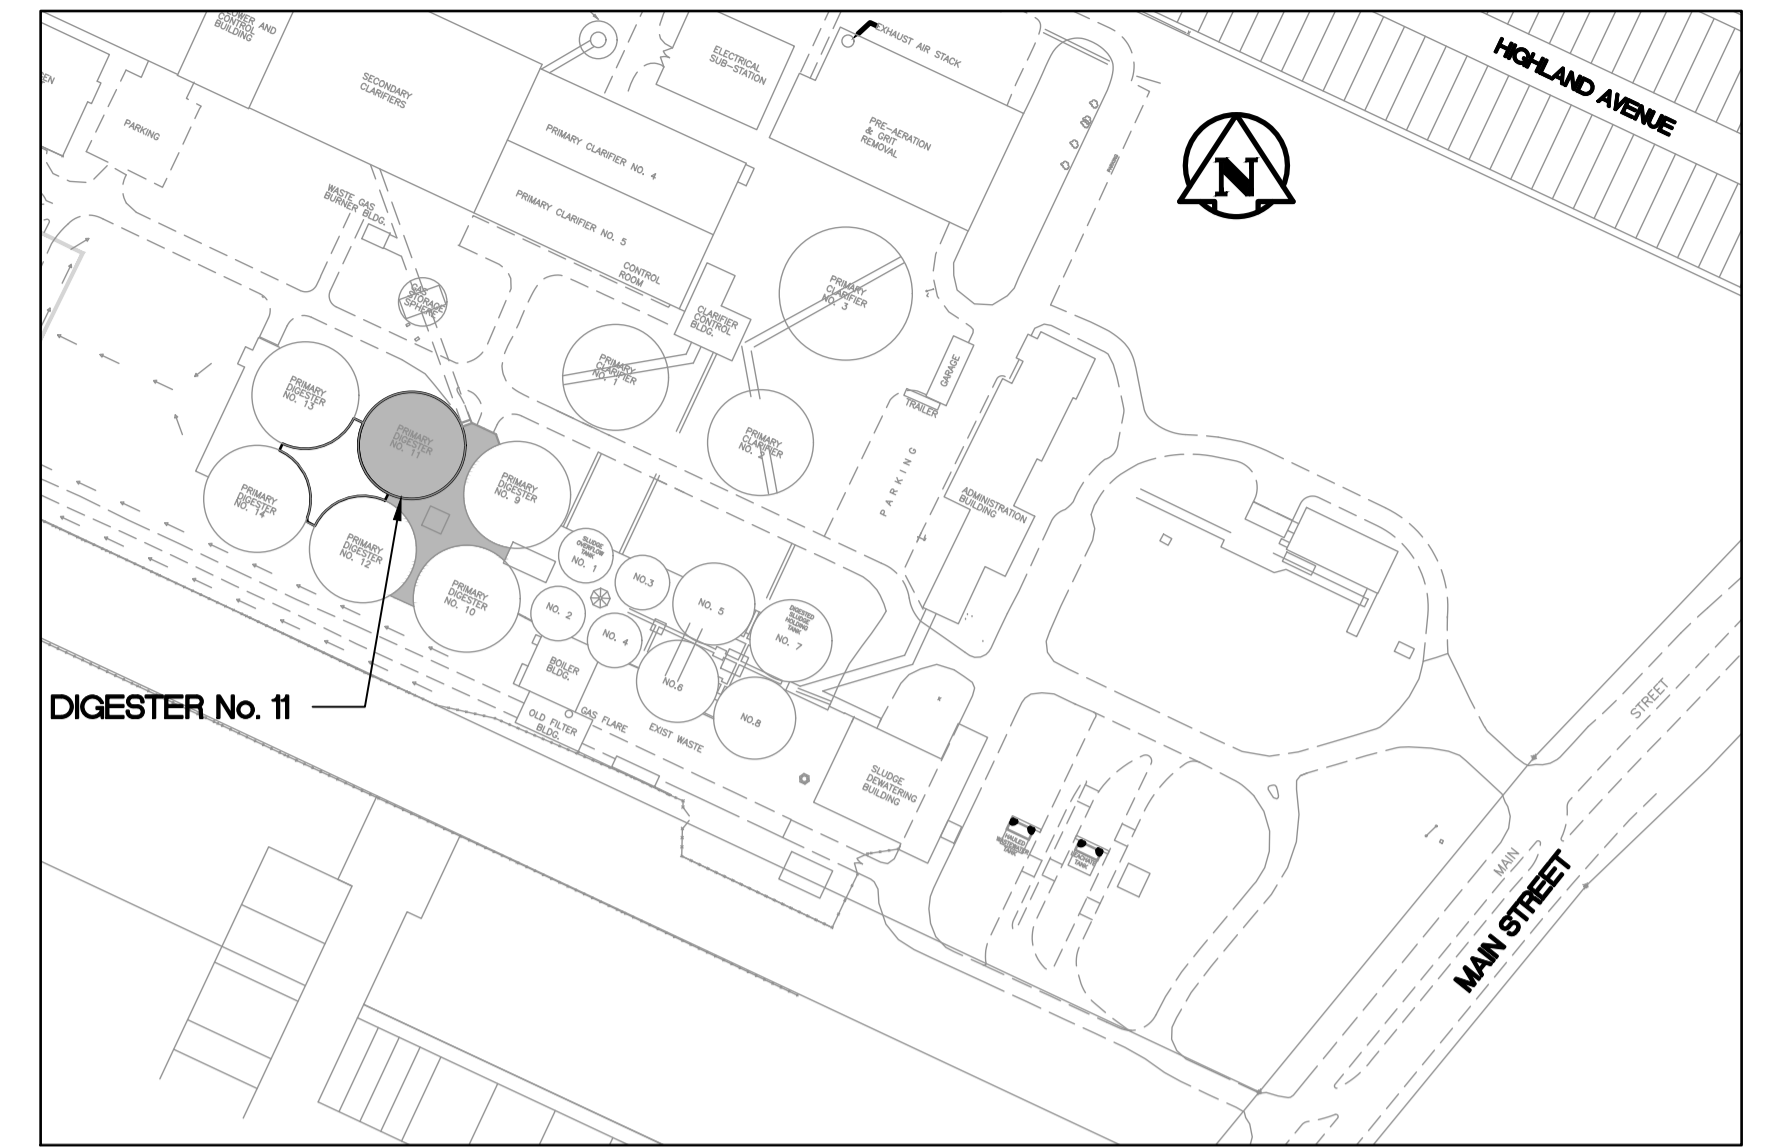

**KEY PLAN**

**DRAWING INDEX**

**GENERAL**

1-0101D-D0002-001	COVER SHEET AND DRAWING LIST	SHEET 1 OF 44
1-0101D-G0002-001	SITE PLAN, LAY-DOWN AND PARKING AREA	SHEET 2 OF 44

**STRUCTURAL**

1-0101D-S0006-001	STRUCTURAL PLAN AND DETAIL, DIGESTER GALLERY 5	SHEET 3 OF 44
-------------------	------------------------------------------------	---------------

**ELECTRICAL**

1-0101D-E0011-001	SINGLE LINE DIAGRAM, MCC LAYOUT AND CONTROL PANEL DETAILS	SHEET 4 OF 44
1-0101D-E0020-001	DIGESTER GALLERY 6 WEST ELECTRICAL ROOM LAYOUT	SHEET 5 OF 44
1-0101D-E0021-001	HAZARDOUS LOCATION PLAN, DIGESTER EAST GAS ROOM	SHEET 6 OF 44
1-0101D-E0022-001	HAZARDOUS LOCATION PLAN, DIGESTER 11 ROOF AND EAST GAS ROOM PENTHOUSE	SHEET 7 OF 44
1-0101D-E0023-001	ELECTRICAL EQUIPMENT PLAN LAYOUT, EAST GAS ROOM	SHEET 8 OF 44
1-0101D-E0024-001	ELECTRICAL EQUIPMENT PLAN LAYOUT, DIGESTER 11 ROOF	SHEET 9 OF 44
1-0101D-E0025-001	CONNECTION DIAGRAM, D375-VFD, MIXING PUMP	SHEET 10 OF 44
1-0101D-E0026-001	CONNECTION DIAGRAM, D376-VFD, MIXING PUMP	SHEET 11 OF 44
1-0101D-E0027-001	WIRING DIAGRAM, D1112-HTR, DIGESTER 11 DOME HEATER	SHEET 12 OF 44
1-0101D-E0028-001	WIRING DIAGRAM, D1113-HTC-1 AND D1113-HTC-2, DIGESTER 11 GAS PIPING HEAT TRACE	SHEET 13 OF 44

**PROCESS AND INSTRUMENTATION DIAGRAMS**

1-0101D-A0071-001	PROCESS AND INSTRUMENTATION DIAGRAM, DIGESTER EAST GAS ROOM HVAC	SHEET 14 OF 44
1-0101D-A0081-001	PROCESS AND INSTRUMENTATION DIAGRAM, LEGEND AND DETAILS	SHEET 15 OF 44
1-0101D-A0082-001	DIGESTER No. 11 MIXING PUMPS P&ID	SHEET 16 OF 44
1-0101D-A0106-001	DIGESTER No. 11 GAS COLLECTION SYSTEM P&ID	SHEET 17 OF 44
1-0101D-A0112-001	PROCESS AND INSTRUMENTATION DIAGRAM, GAS DETECTION AND ALARMING, EAST GAS ROOM	SHEET 18 OF 44

**AUTOMATION**

1-0101D-A0113-001	INSTRUMENT LOCATION PLAN, DIGESTER EAST GAS ROOM	SHEET 19 OF 44
1-0101D-A0113-002	INSTRUMENT LOCATION PLAN, DIGESTER EAST GAS ROOM	SHEET 20 OF 44
1-0101D-A0113-003	INSTRUMENT LOCATION PLAN, DIGESTER EAST GAS ROOM	SHEET 21 OF 44
1-0101D-A0113-004	INSTRUMENT LOCATION PLAN, DIGESTER EAST GAS ROOM	SHEET 22 OF 44
1-0101D-A0114-001	INSTRUMENT LOCATION PLAN, DIGESTER 11, DIGESTER 12 ROOF AND EAST GAS ROOM PENTHOUSE	SHEET 23 OF 44
1-0101D-A0115-001	CONTROL ROOM LAYOUT, DIGESTER CONTROL ROOM	SHEET 24 OF 44
1-0101D-A0116-001	LOOP DIAGRAM, D130-LIT, DIGESTER 11 FOAM LEVEL	SHEET 25 OF 44
1-0101D-A0117-001	LOOP DIAGRAM, D142-FIT, DIGESTER 11 GAS FLOW	SHEET 26 OF 44
1-0101D-A0118-001	LOOP DIAGRAM, D379-XV, MIXING PUMP DISCHARGE VALVE	SHEET 27 OF 44
1-0101D-A0119-001	LOOP DIAGRAM, D380-XV, MIXING PUMP DISCHARGE VALVE	SHEET 28 OF 44
1-0101D-A0120-001	LOOP DIAGRAM, D384-XV-1 AND D384-XV-2, FLUSHING WATER SOLENOIDS	SHEET 29 OF 44
1-0101D-A0121-001	LOOP DIAGRAM, D386-PIT, MIXING PUMP DISCHARGE PRESSURE	SHEET 30 OF 44
1-0101D-A0122-001	GAS DETECTION SCHEDULE, D939-GDC, EAST GAS ROOM	SHEET 31 OF 44
1-0101D-A0123-001	LOOP DIAGRAM, D939-AIT-1 AND D939-AIT-2, EAST GAS ROOM GAS DETECTION	SHEET 32 OF 44
1-0101D-A0124-001	LOOP DIAGRAM, D939-AIT-3 AND D939-AIT-4, EAST GAS ROOM GAS DETECTION	SHEET 33 OF 44
1-0101D-A0125-001	LOOP DIAGRAM, D939-AIT-5 AND D939-AIT-6, EAST GAS ROOM GAS DETECTION	SHEET 34 OF 44
1-0101D-A0126-001	LOOP DIAGRAM, D939-GDC STROBES, SIRENS AND VENTILATION CONTROL, EAST GAS ROOM GAS DETECTION	SHEET 35 OF 44
1-0101D-A0126-002	LOOP DIAGRAM, D939-GDC STROBES, SIRENS AND VENTILATION CONTROL, EAST GAS ROOM GAS DETECTION	SHEET 36 OF 44
1-0101D-A0127-001	LOOP DIAGRAM, D939-GDC, DCS ALARMS	SHEET 37 OF 44
1-0101D-A0128-001	LOOP DIAGRAM, D638-DF3, DCS AND GAS DETECTION CONTROL	SHEET 38 OF 44
1-0101D-A0129-001	LOOP DIAGRAM, D512-DF12, DCS AND GAS DETECTION CONTROL	SHEET 39 OF 44
1-0101D-A0130-001	LOOP DIAGRAM, D613-DF13, DCS AND GAS DETECTION CONTROL	SHEET 40 OF 44
1-0101D-A0131-001	INSTALLATION DETAILS, COMBUSTIBLE GAS DETECTION	SHEET 41 OF 44
1-0101D-A0132-001	JUNCTION BOX LAYOUT, JBA-D939-1 AND JBA-D939-2, COMBUSTIBLE GAS DETECTION	SHEET 42 OF 44
1-0101D-A0133-001	NETWORK DIAGRAM, FIELD NETWORK, DIGESTER GALLERY PLC PANEL	SHEET 43 OF 44
1-0101D-A0134-001	PANEL LAYOUT, CP-D91 GAS DETECTION PANEL	SHEET 44 OF 44

<b>LOCATION APPROVED UNDERGROUND STRUCTURES</b> SUPV. U/G STRUCTURES COMMITTEE DATE NOTE: LOCATION OF UNDERGROUND STRUCTURES AS SHOWN ARE BASED ON THE BEST INFORMATION AVAILABLE BUT NO GUARANTEE IS GIVEN THAT ALL EXISTING UTILITIES ARE SHOWN OR THAT THE GIVEN LOCATIONS ARE EXACT. CONFIRMATION OF EXISTENCE AND EXACT LOCATION OF ALL SERVICES MUST BE OBTAINED FROM THE INDIVIDUAL UTILITIES BEFORE PROCEEDING WITH CONSTRUCTION.	B.M. ELEV. <table border="1"> <tr><td> </td><td> </td><td> </td><td> </td></tr> <tr><td> </td><td> </td><td> </td><td> </td></tr> <tr><td> </td><td> </td><td> </td><td> </td></tr> <tr><td> </td><td> </td><td> </td><td> </td></tr> </table>																		ENGINEER'S SEAL	THE CITY OF WINNIPEG WATER AND WASTE DEPARTMENT <b>NORTH END SEWAGE TREATMENT PLANT          NEWPCC DIGESTER 11 ELECTRICAL AND AUTOMATION UPGRADES          PROJECT COVER SHEET AND DRAWING LIST</b>
DESIGNED BY: C. REIMER CHECKED BY: C. REIMER DRAWN BY: S. FUNK APPROVED BY: C. REIMER HOR. SCALE: VERTICAL: RELEASED FOR CONSTRUCTION: K. SCHIMKE	BID OPPORTUNITY NO. 630-2019 CITY DRAWING NUMBER 1-0101D-D0002-001 SHEET 1 OF 44																			