


# THE CITY OF WINNIPEG

## WATER AND WASTE DEPARTMENT

### BRADY ROAD LANDFILL STANDBY GENERATOR

### BID OPPORTUNITY: 393-2020

CITY OF WINNIPEG DWG. No.	SHEET No.	DWG. No.	TITLE
393-2020_DRAWING_20-0107-004_G01	1 of 1	G00	ELECTRICAL - COVER SHEET
393-2020_DRAWING_20-0107-004_E01	1 of 7	E01	ELECTRICAL - SYMBOL LEGEND, GENERAL NOTES, AND DRAWING LIST
393-2020_DRAWING_20-0107-004_E02	2 of 7	E02	ELECTRICAL - SITE PLAN - NEW
393-2020_DRAWING_20-0107-004_E03	3 of 7	E03	ELECTRICAL - ADMINISTRATION BUILDING
393-2020_DRAWING_20-0107-004_E04	4 of 7	E04	ELECTRICAL - COMMERCIAL SCALE BUILDING
393-2020_DRAWING_20-0107-004_E05	5 of 7	E05	ELECTRICAL - SINGLE LINE DIAGRAM
393-2020_DRAWING_20-0107-004_E05.1	6 of 7	E05.1	ELECTRICAL - PANEL SCHEDULES
393-2020_DRAWING_20-0107-004_E06	7 of 7	E06	ELECTRICAL - SPECIFICATIONS - DIV.26
393-2020_DRAWING_20-0107-004_S01	1 of 1	S01	STRUCTURAL - NEW ELECTRICAL ROOM AND GENERATOR PAD

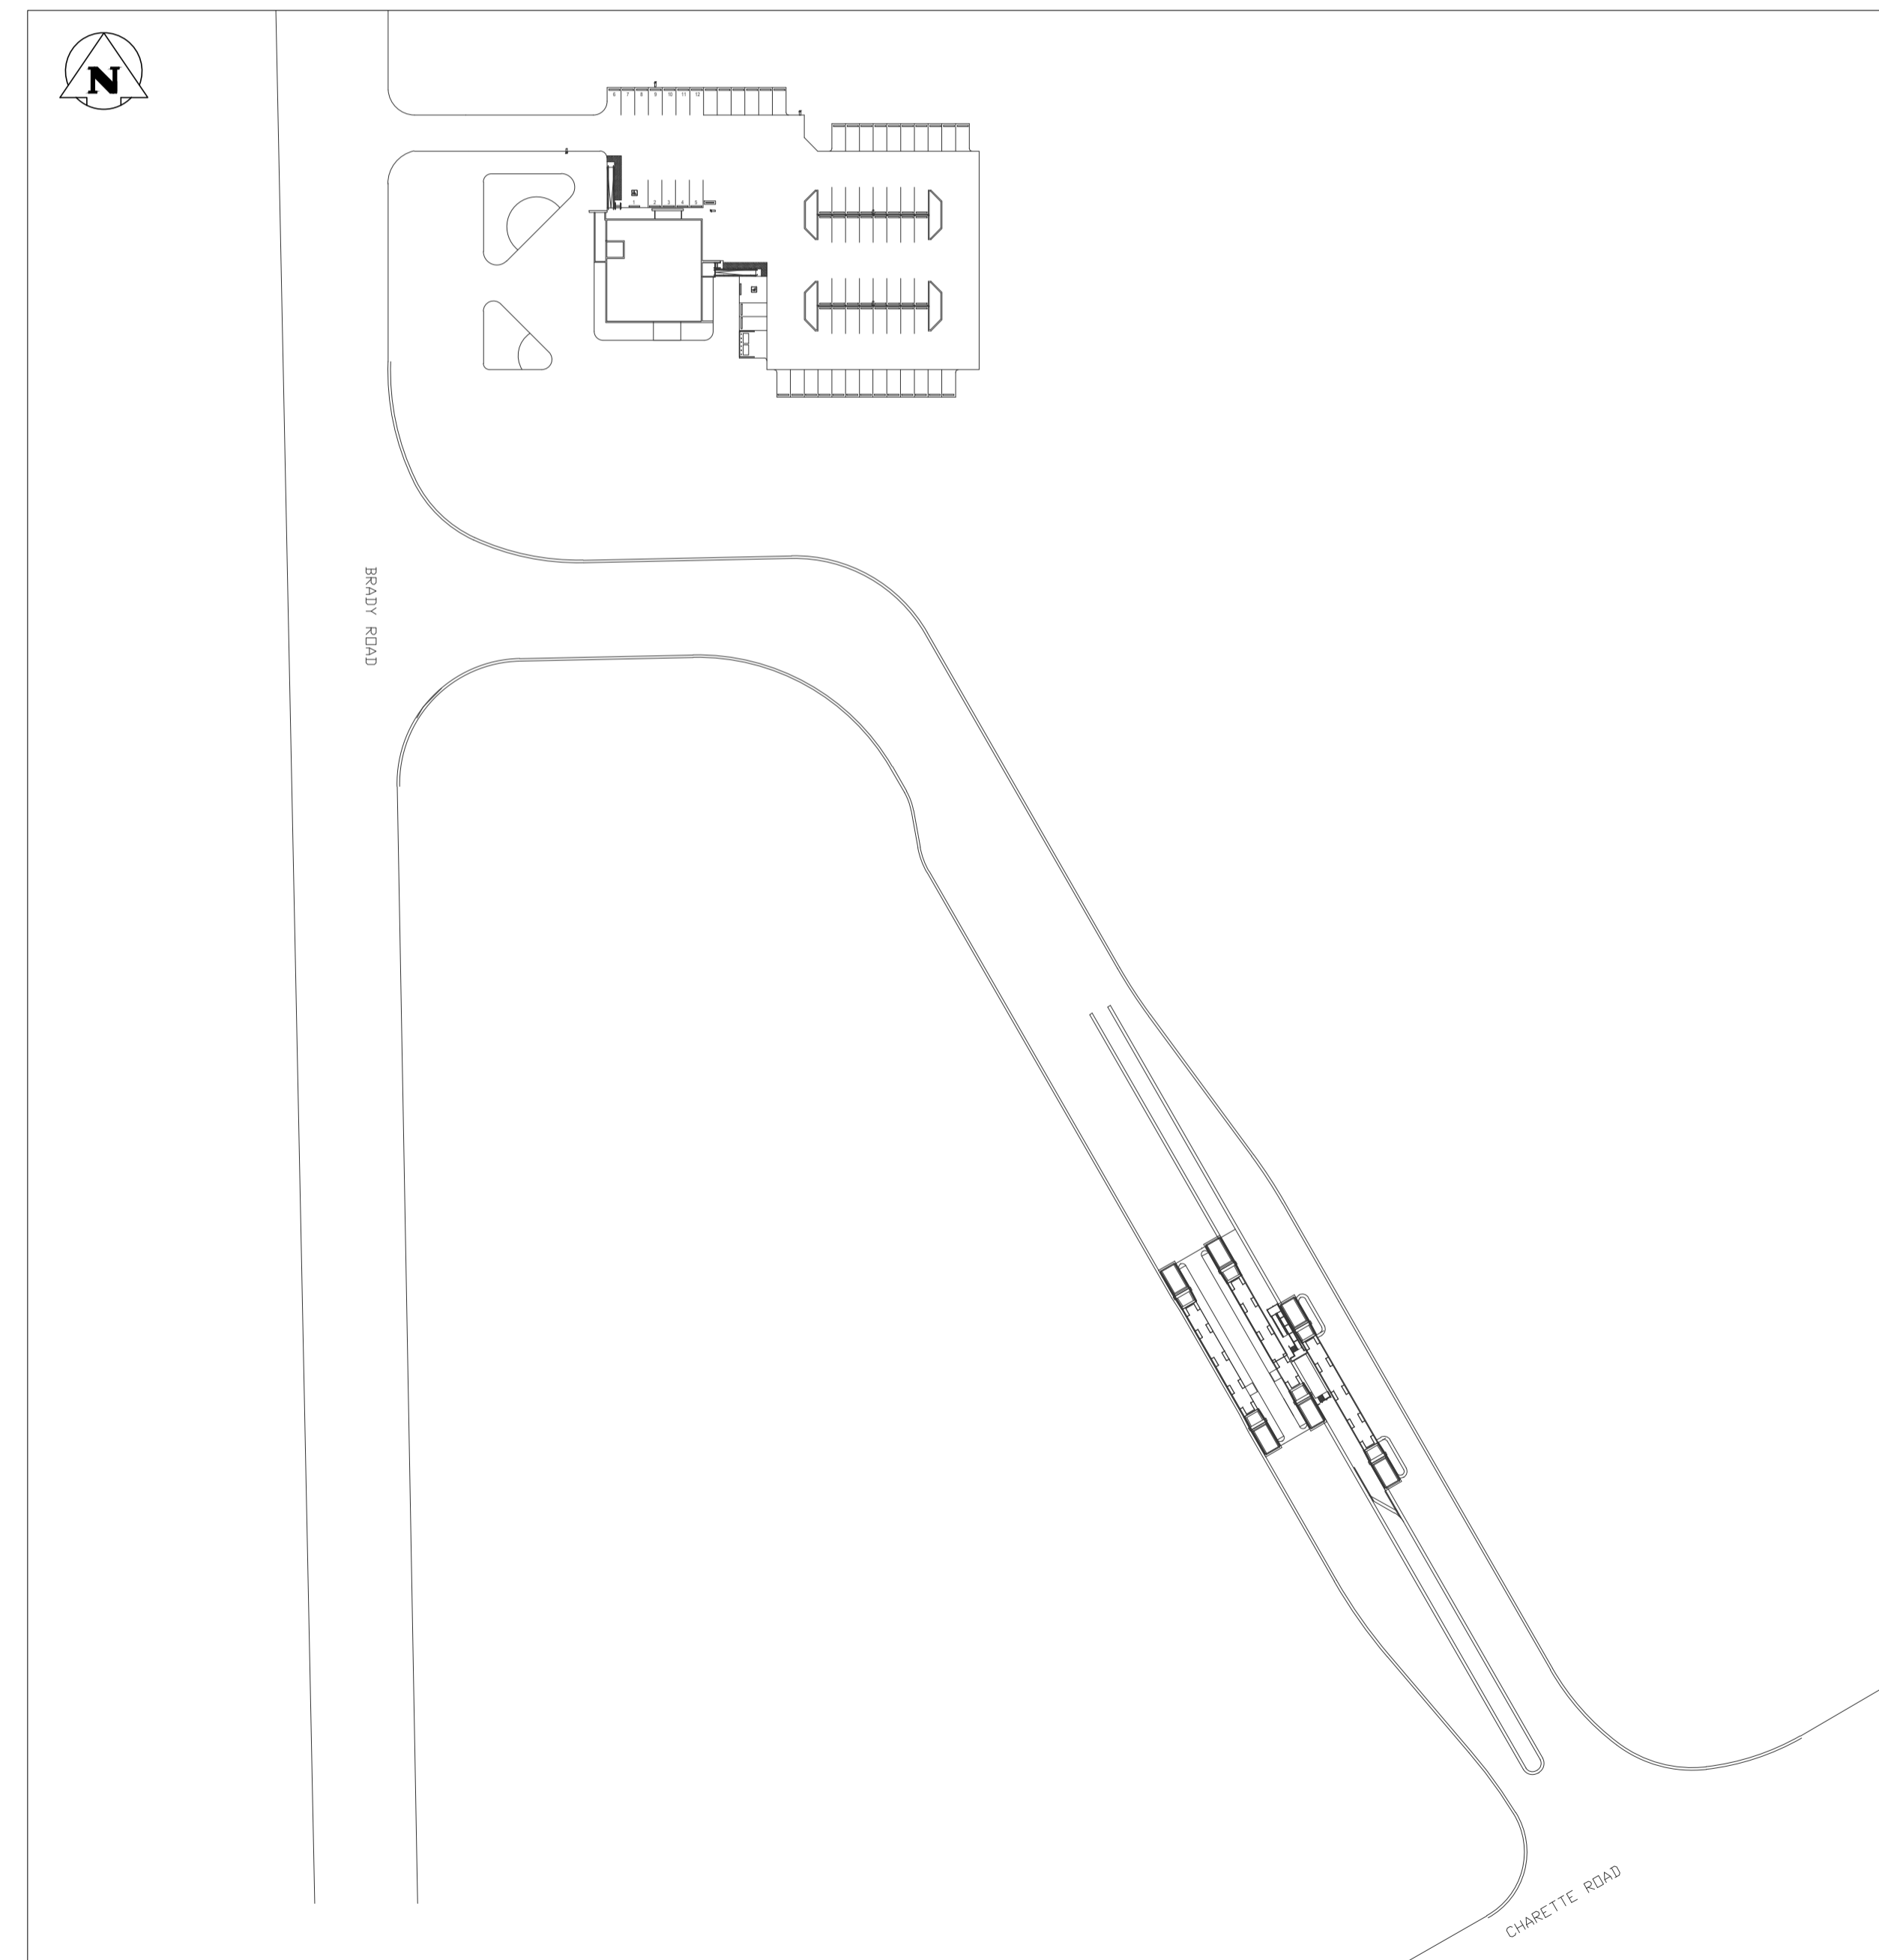

LOCATION PLAN  
(NTS)