
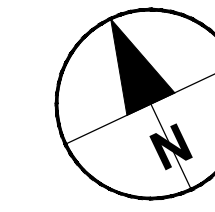


D SIZE 22" x 34" (559mm x 864mm)

PLOT: 11/15/2020 2:08:11 PM

AECOM REVIEW DRFT CHK AECOM FILE NAME: 60509089-SHT-30-0000-E-1001 E-1002.dwg Saved By: pedersenj

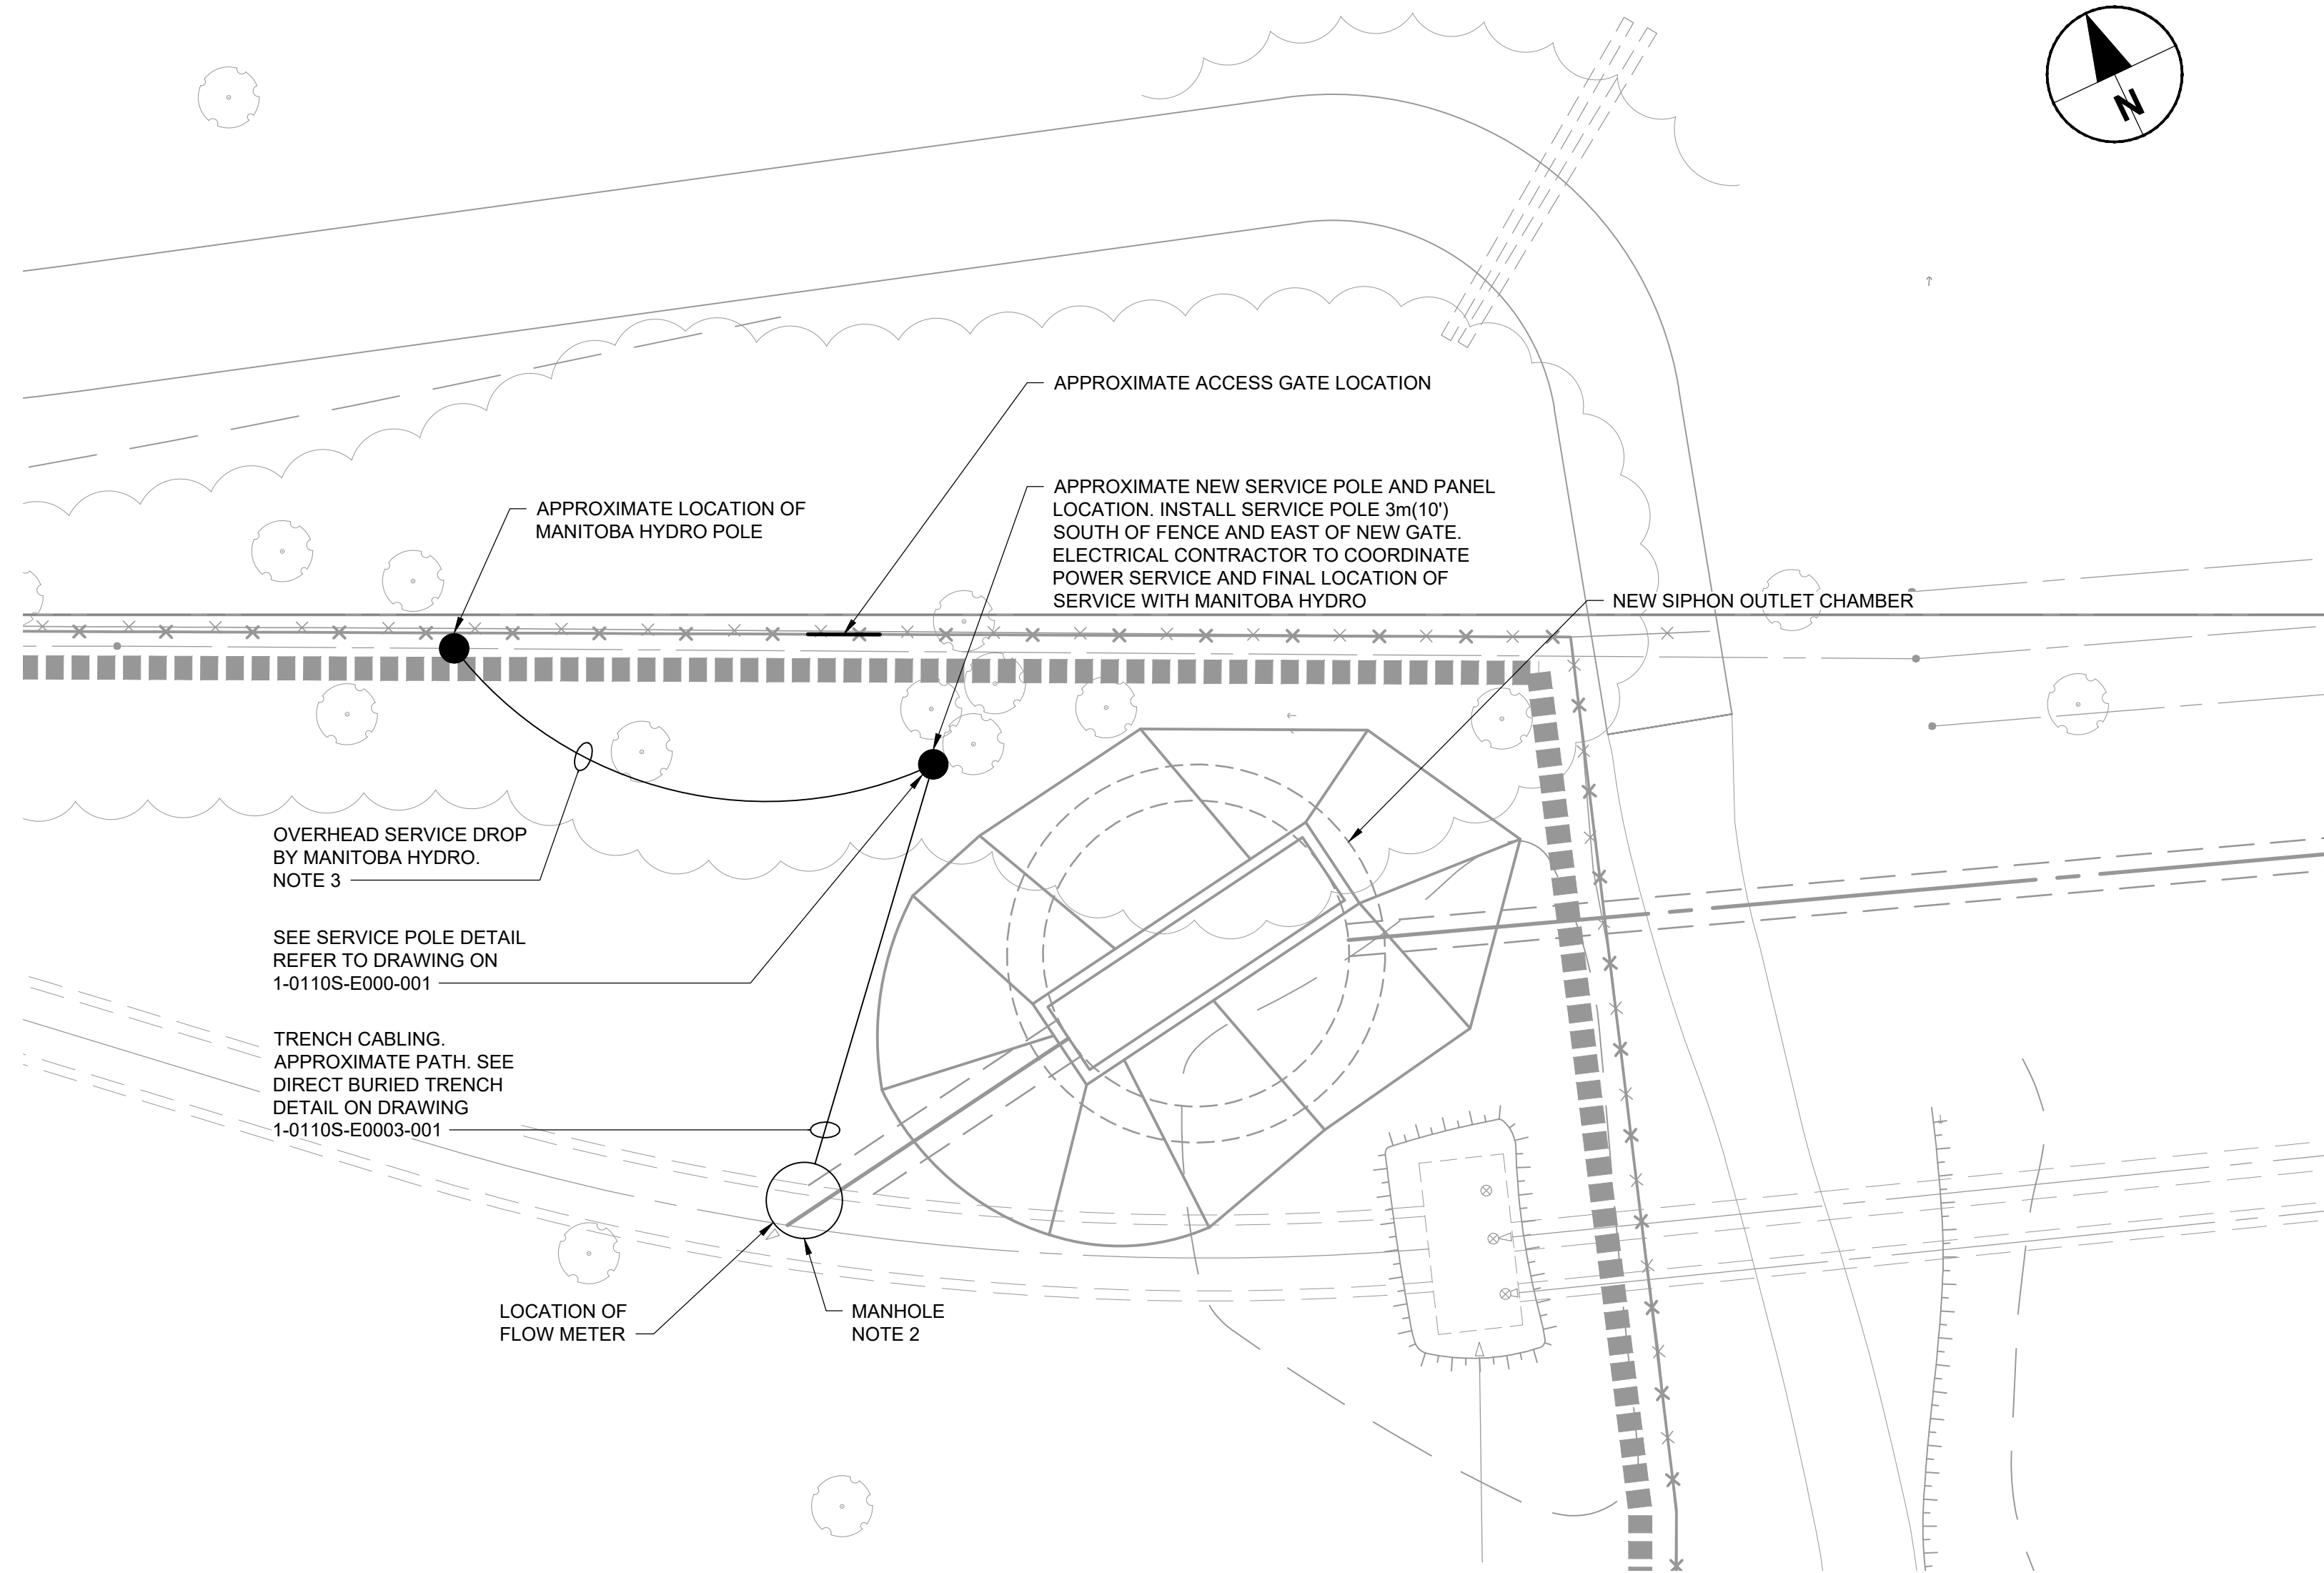

### SITE PLAN WEST OF RED RIVER - ELECTRICAL

Scale 1:150

**NOTES:**

1. TAKE CARE TO MINIMIZE DAMAGE TO TREES AND SHRUBBERY.
2. CORE AND SLEEVE CABLING THROUGH CONCRETE. FILL SLEEVE WITH WATERTIGHT SEALANT. SEE SPECIFICATIONS.
3. CONTRACTOR TO COORDINATE WITH MANITOBA HYDRO PRIOR TO COMMENCING WORKS.

**ENGINEERS GEOSCIENTISTS MANITOBA**  
 Certificate of Authorization  
 AECOM Canada Ltd.  
 No. 4671 Date: 20/11/05

TENDER NO. 753-2020

<p><b>LOCATION APPROVED</b> UNDERGROUND STRUCTURES</p> <p>SUPR. U/G STRUCTURES DATE COMMITTEE</p> <p><b>NOTE:</b> LOCATION OF UNDERGROUND STRUCTURES AS SHOWN ARE BASED ON THE BEST INFORMATION AVAILABLE. BUT NO GUARANTEE IS GIVEN THAT ALL EXISTING UTILITIES ARE SHOWN OR THAT THE GIVEN LOCATIONS ARE EXACT. CONFIRMATION OF EXISTENCE AND EXACT LOCATION OF ALL SERVICES MUST BE OBTAINED FROM THE INDIVIDUAL UTILITIES BEFORE PROCEEDING WITH CONSTRUCTION.</p>									
	<h1 style="margin: 0;">AECOM</h1>				<p>DESIGNED BY MP/JR</p> <p>CHECKED BY SS</p>				
					<p>DRAWN BY RC</p> <p>APPROVED BY DA</p>		<p>CONSULTANT DRAWING NO. 60509089-SHT-30-0000-E-1001</p>		
					<p>HOR. SCALE 1:150</p> <p>VERT. SCALE N/A</p> <p>DATE</p>				
				<p>0 ISSUED FOR CONSTRUCTION 20/11/05 KLC</p>		<p><b>THE CITY OF WINNIPEG</b> WATER AND WASTE DEPARTMENT</p>			
				<p>NO. REVISIONS YYMMDD BY</p>		<p><b>NORWEST INTERCEPTOR RIVER CROSSING</b> FLOW MONITORING INSTRUMENTATION</p>			
				<p>0</p>		<p>FLOW MONITORING SITE PLAN WEST OF RED RIVER</p>			
				<p>1 OF 5</p>		<p>SHEET 1 OF 5 CITY DRAWING NUMBER 1-0110S-E0001-001 REV 0</p>			

**METRIC**  
 WHOLE NUMBERS INDICATE MILLIMETRES  
 DECIMALIZED NUMBERS INDICATE METRES