


PLATFORM 1 FRAMING PLAN
SCALE: 1:40 T/O GRATING EL. 105 000 U.N.O.

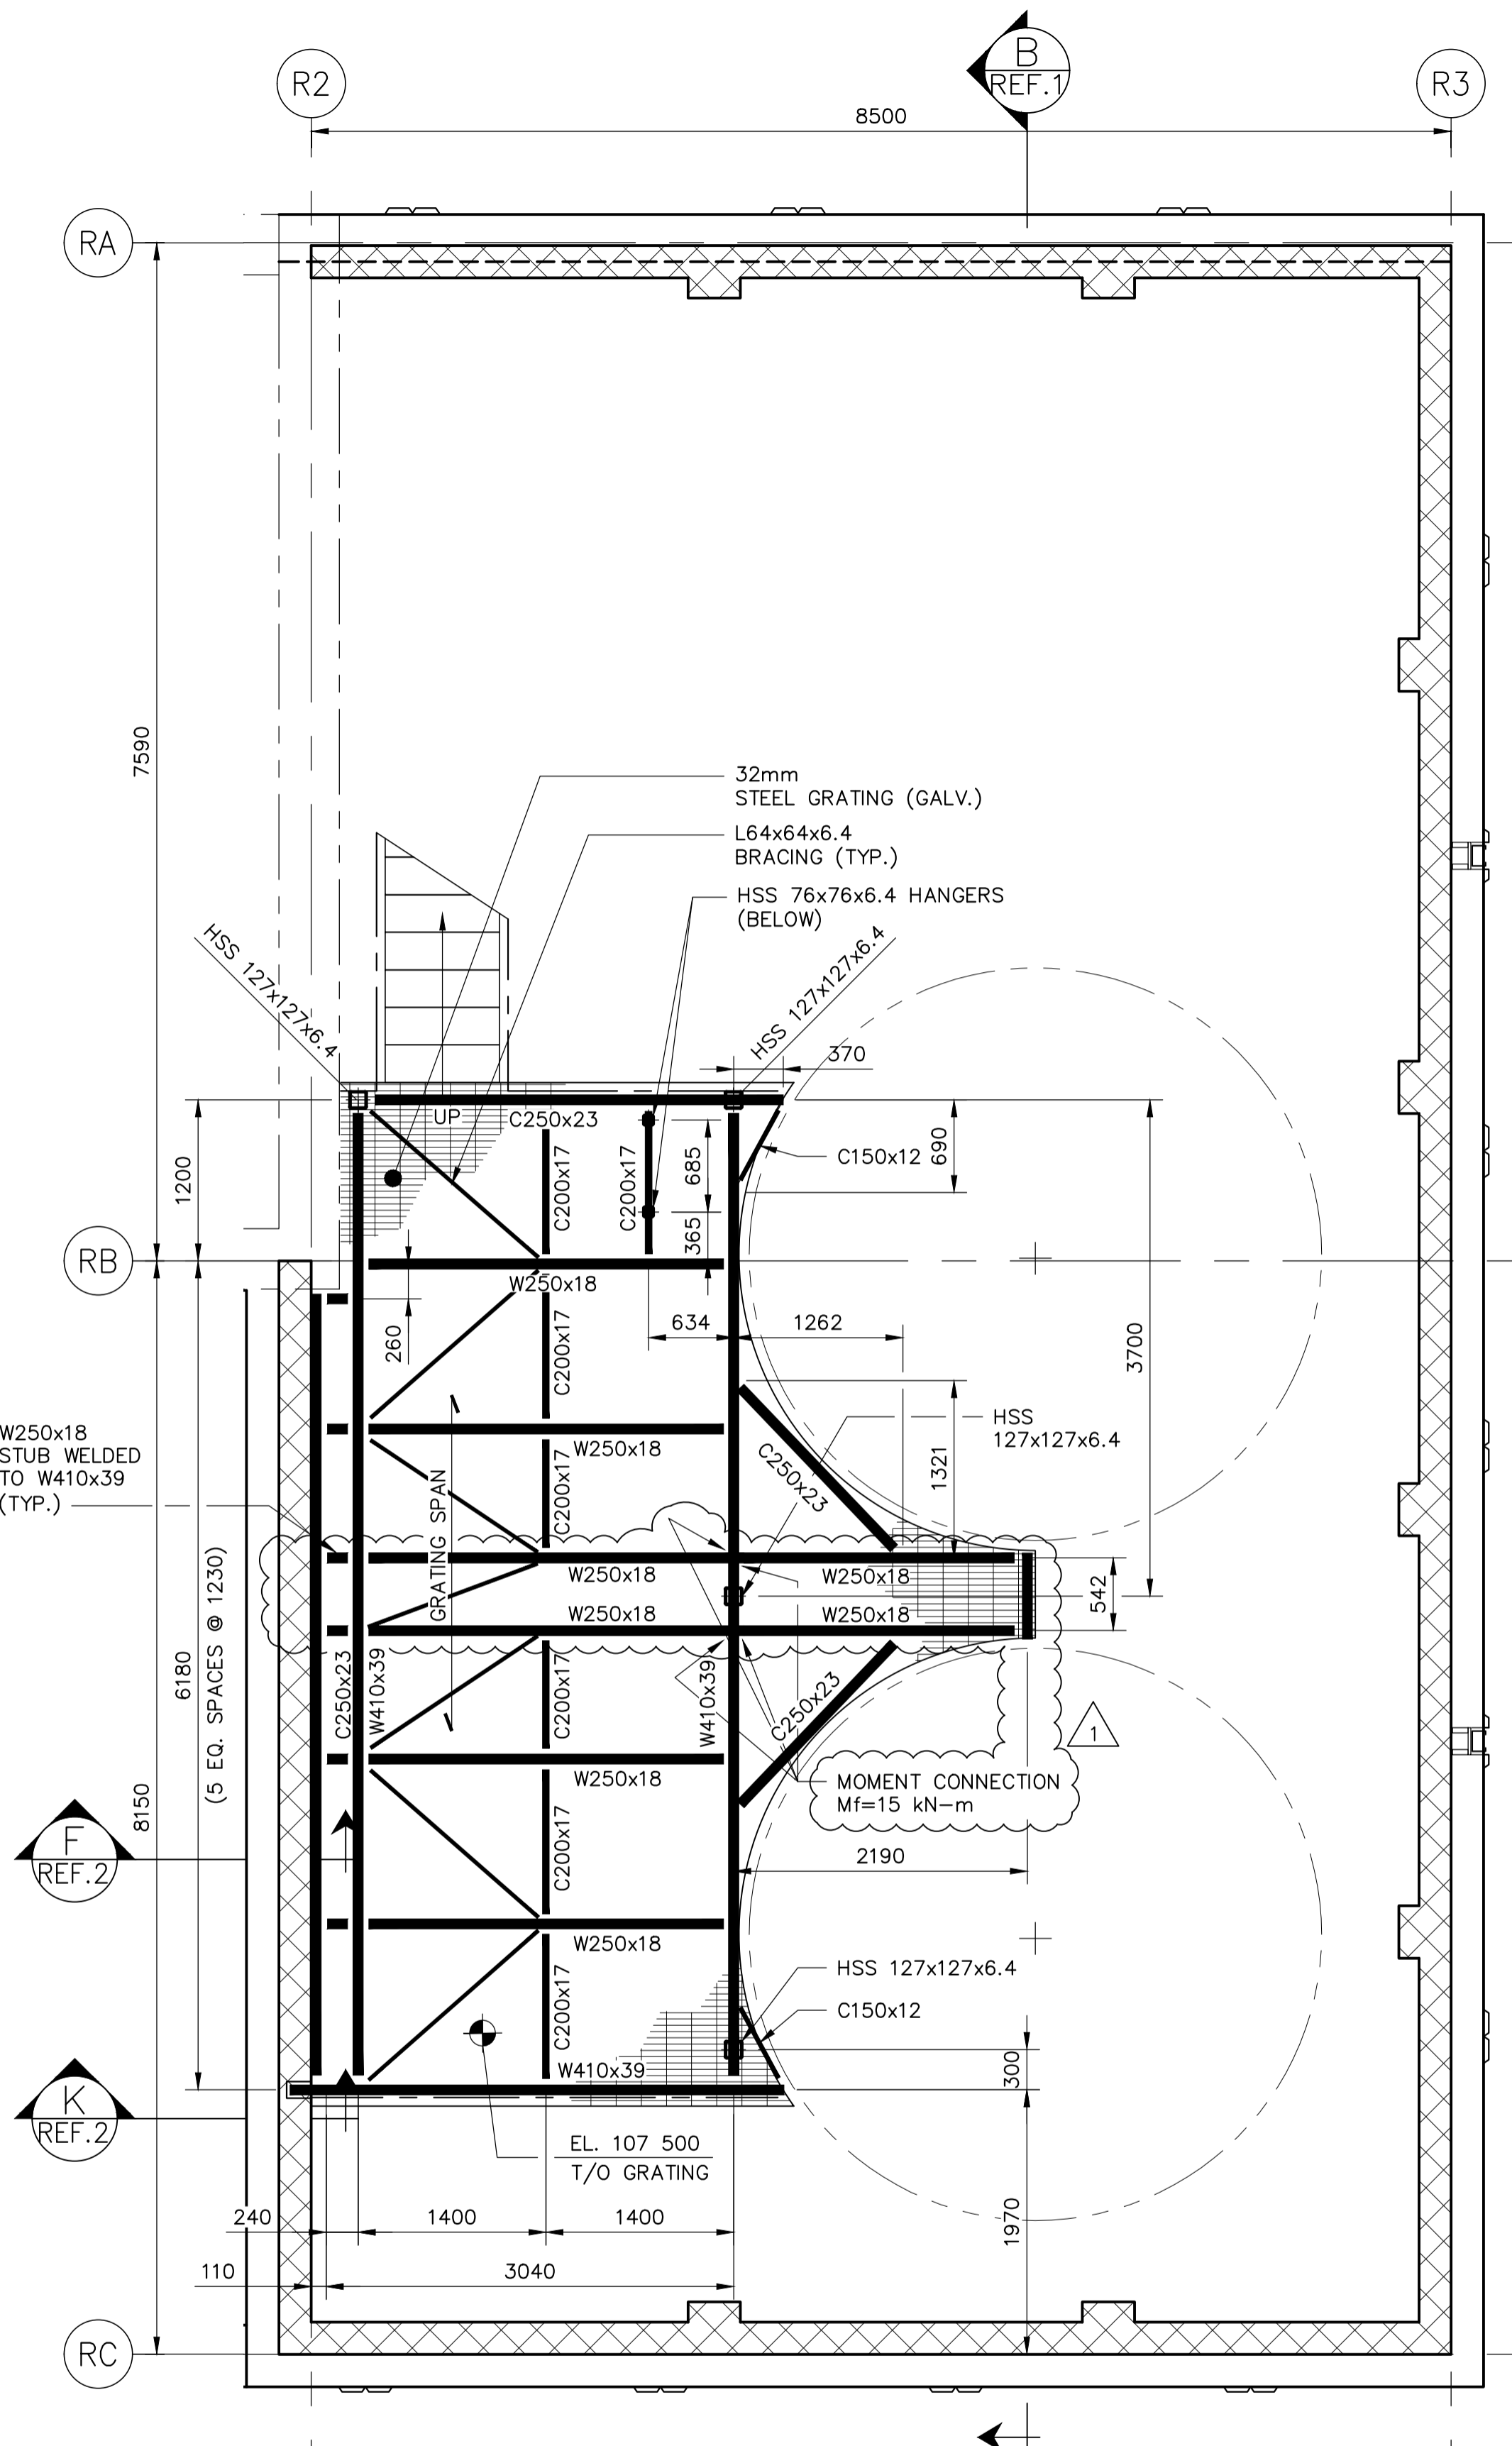

PLATFORM 2 FRAMING PLAN
SCALE: 1:40 T/O GRATING EL. 107 500 U.N.O.

DESIGN LOADS:
FLOOR DEAD (STEEL): 1 kPa
FLOOR LIVE: 4.8 kPa
EQUIPMENT: AS SHOWN

10		
9		
8		
7		
6		
5		
4		
3		
2	1-0101-SDTL-F201-001	SECTIONS AND DETAILS
1	1-0101-SGAD-F204-001	SECTIONS
NO.	DRAWING NUMBER	REFERENCE DRAWING TITLE
REFERENCE DRAWINGS		



B.M. ELEV.			
CONSTRUCTION COMPLETION DATE: YYYY MM DD			
NO.	REVISIONS	DATE	BY
1	RE-ISSUED FOR CONSTRUCTION	2022 06 17	JMW
0	ISSUED FOR CONSTRUCTION	2022 05 18	JMW

KGS GROUP

DESIGNED BY: J. WALTER
CHECKED BY: CMS
DRAWN BY: F. VALENCIA
APPROVED BY: JMW
SCALE: AS SHOWN
RELEASED FOR CONSTRUCTION

DATE: 2022 02 24
PLOT DATE: 2022 06 17

ENGINEER'S SEAL
CONSULTANT DRAWING NUMBER
21-0107-015_S2.104

THE CITY OF WINNIPEG
WATER AND WASTE DEPARTMENT
ENGINEERING DIVISION

Winnipeg

NORTH END SEWAGE TREATMENT PLANT (NEWPPC)
INTERIM PHOSPHOROUS REMOVAL
AREA F - CHEMICAL RECEIVING AND STORAGE FACILITY
PLATFORMS 1 & 2 FRAMING PLANS
BUILDING 101

CITY DRAWING NUMBER: 1-0101-SSST-F201-001
SHEET 1 OF 1