

PROVIDE TEMPORARY FACILITY PROTECTION AS SPECIFIED

EE
WB-B0203

FF
WB-B0204

GG
WB-B0204

14
WB-B0254

2
WB-B0430


PROVIDE TEMPORARY FACILITY AS SPECIFIED

THIRD FLOOR PLAN
SCALE 1:300


CITY OF WINNIPEG
DRINKING WATER TREATMENT PLANT
ROOF REPLACEMENT
TENDER 37-2023

APPENDIX A - FACILITY PROTECTION


THIRD FLOOR PLAN

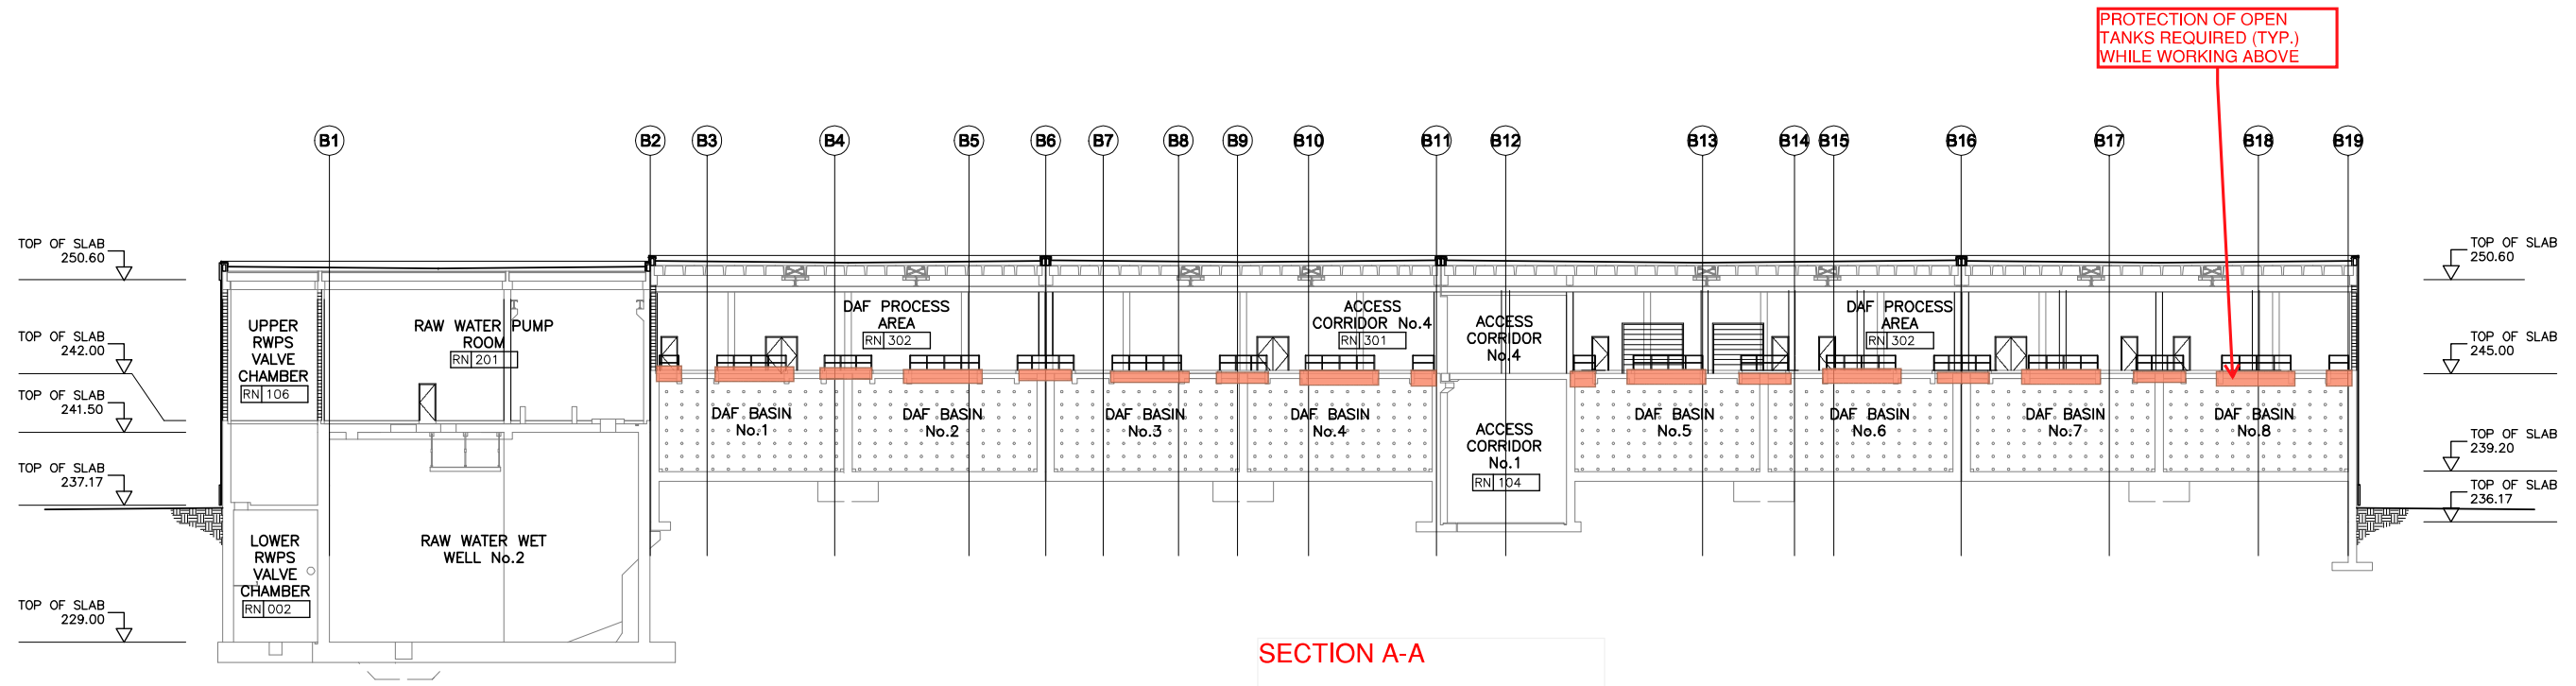

SECTION A-A

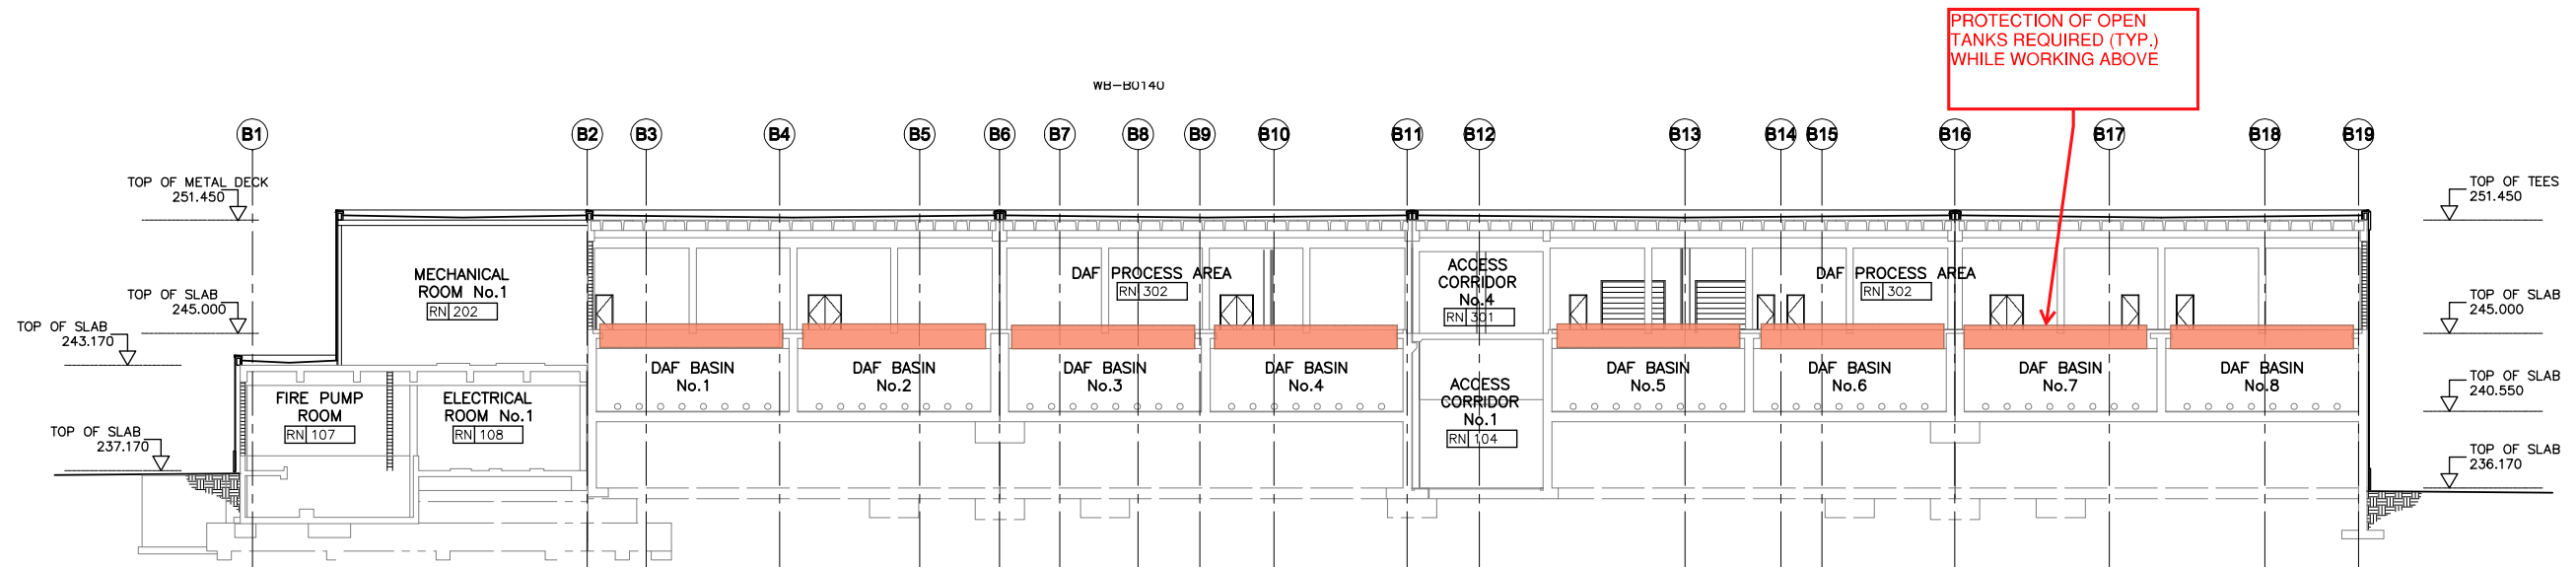

SECTION B-B

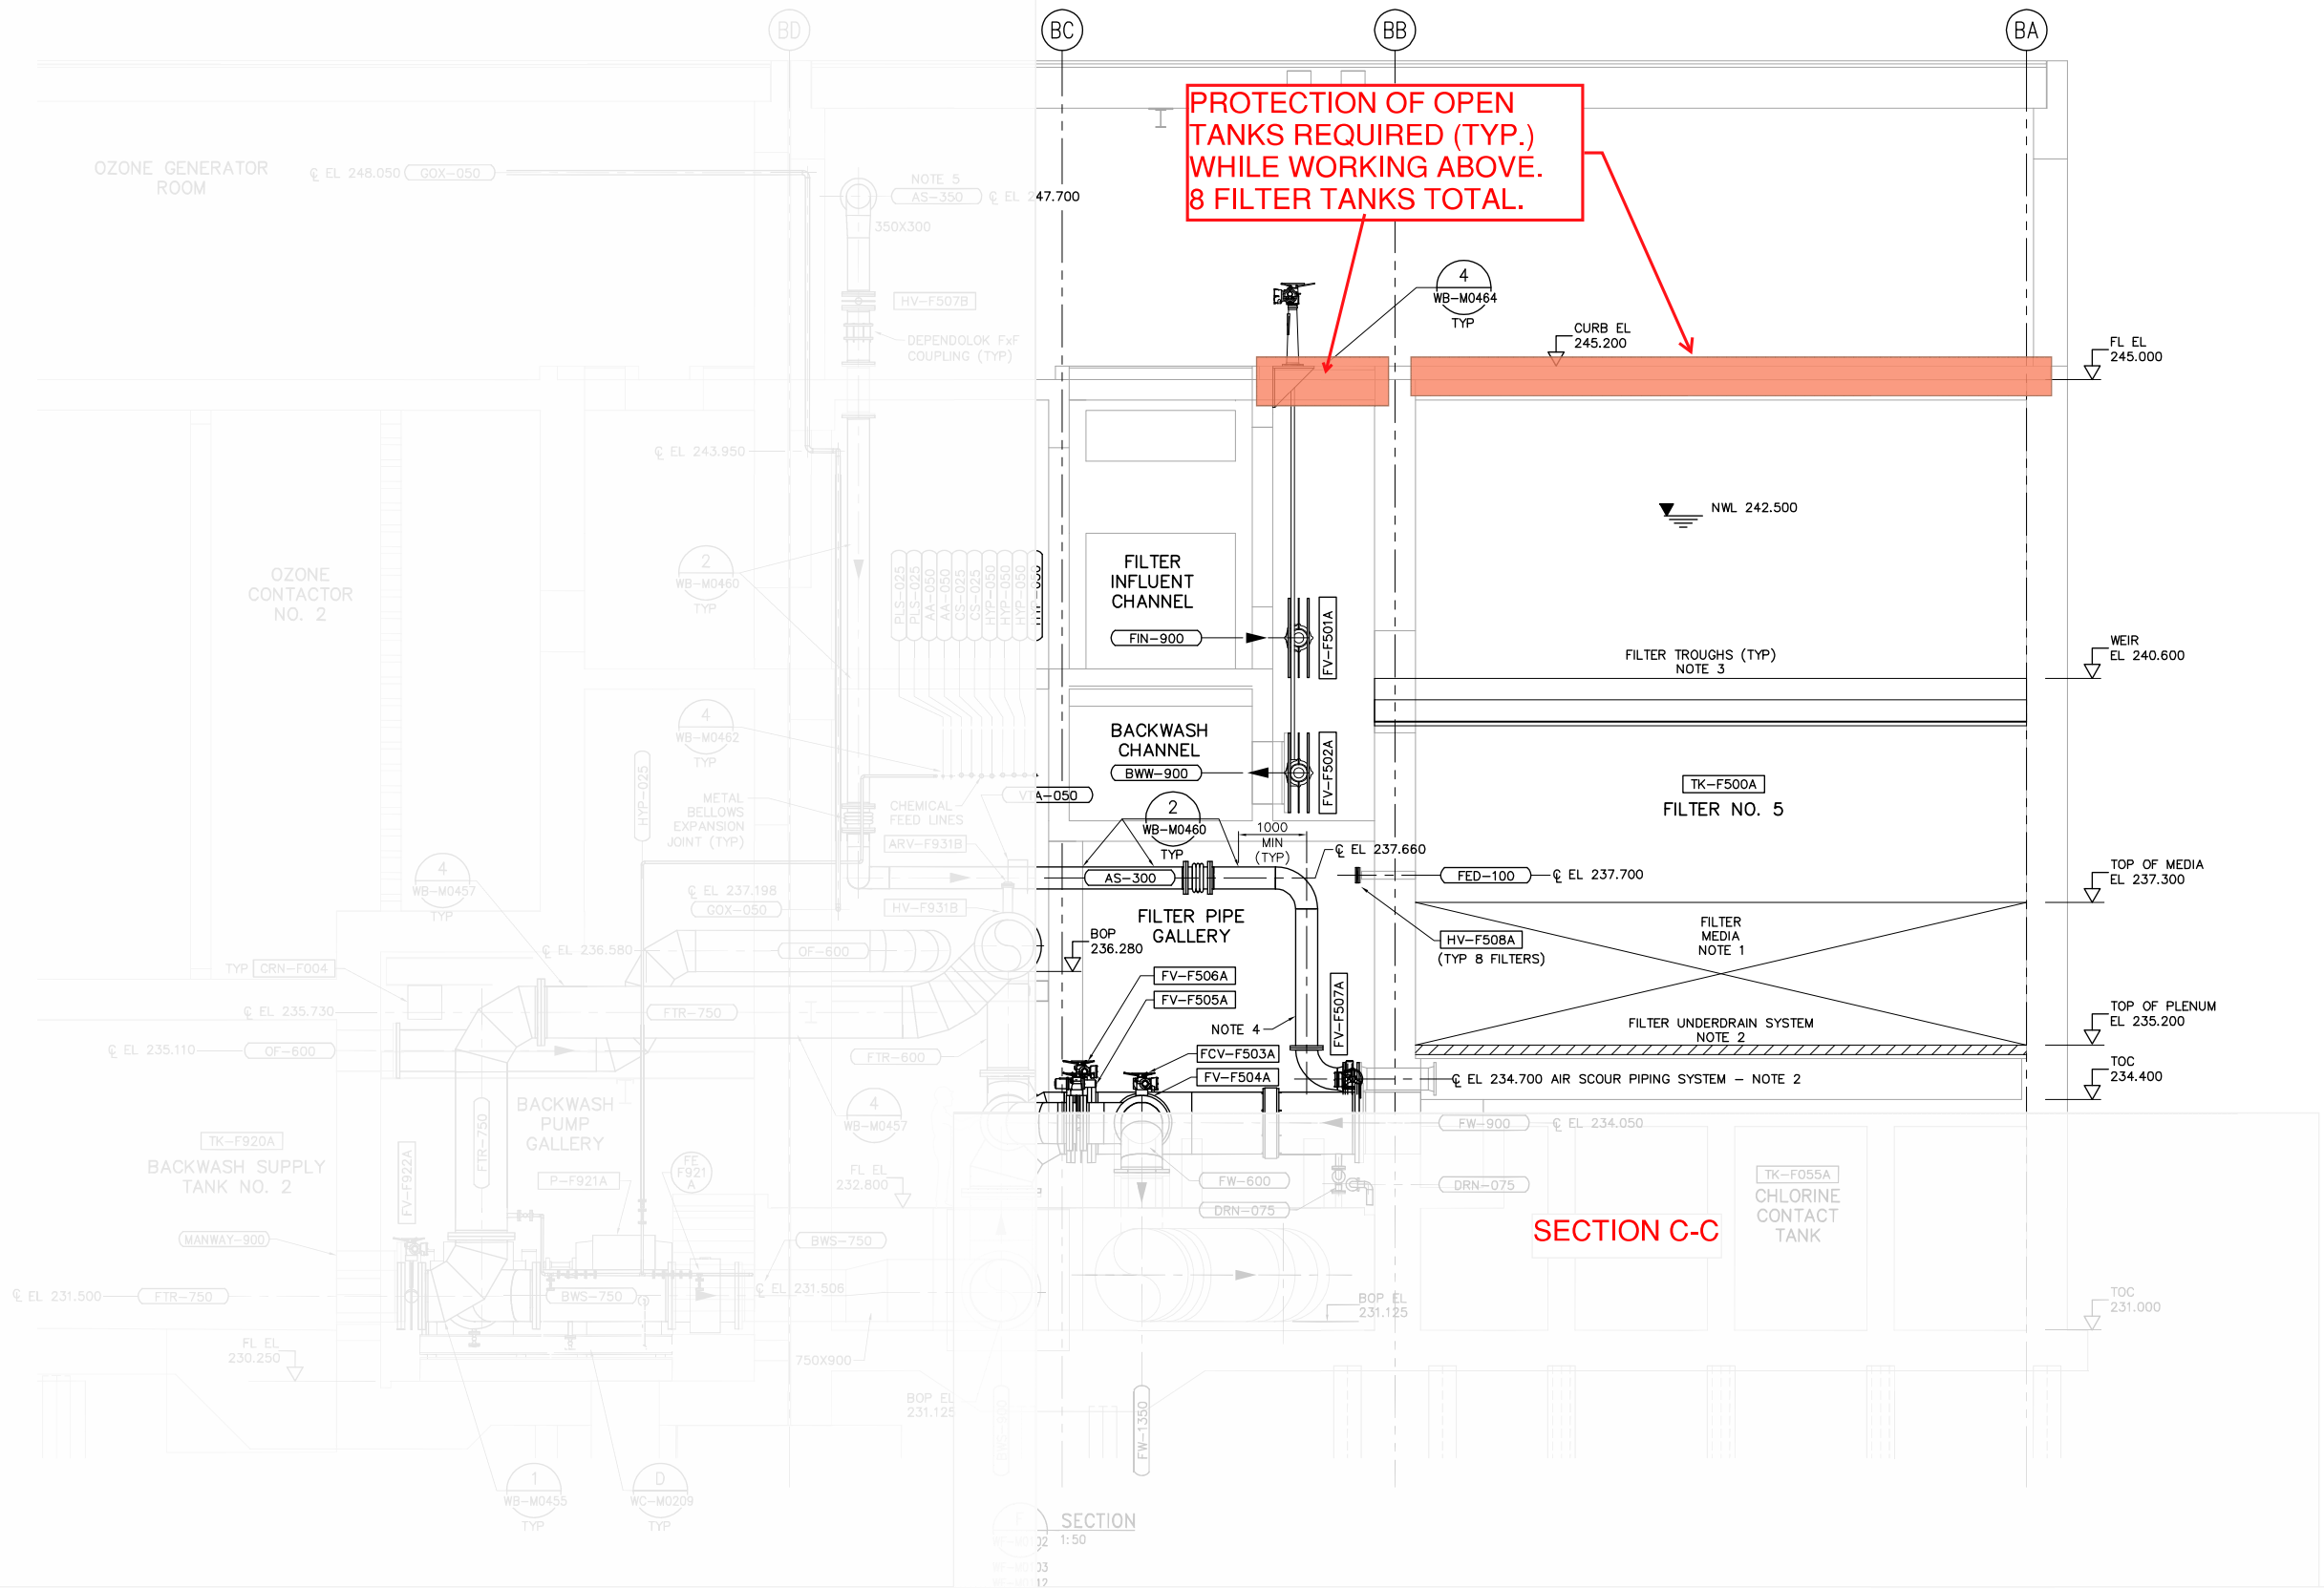

NOTES:

1. FILTER MEDIA SUPPLY AND INSTALLATION BY OTHERS, COORDINATION BY CONTRACTOR (SEE SPEC. 11003).
2. FILTER UNDERDRAIN PARTIAL SUPPLY BY OTHERS, INSTALLATION AND COORDINATION BY CONTRACTOR BASED ON SHOP DRAWINGS (SEE SPEC. 11004).
3. FILTER TROUGH SUPPLY BY OTHERS, INSTALLATION AND COORDINATION BY CONTRACTOR BASED ON SHOP DRAWINGS (SEE SPEC. 11005).
4. INSULATE EXPOSED AS-300 PIPE BELOW EL. 236.000.
5. INSULATE EXPOSED AS-300

CITY OF WINNIPEG
 DRINKING WATER TREATMENT PLANT
 ROOF REPLACEMENT
 TENDER 37-2023

APPENDIX A - FACILITY PROTECTION
 SECTION C-C