




1 ROOF DETAIL AT EXPANSION JOINT  
1-0601B-00076-003 1:5

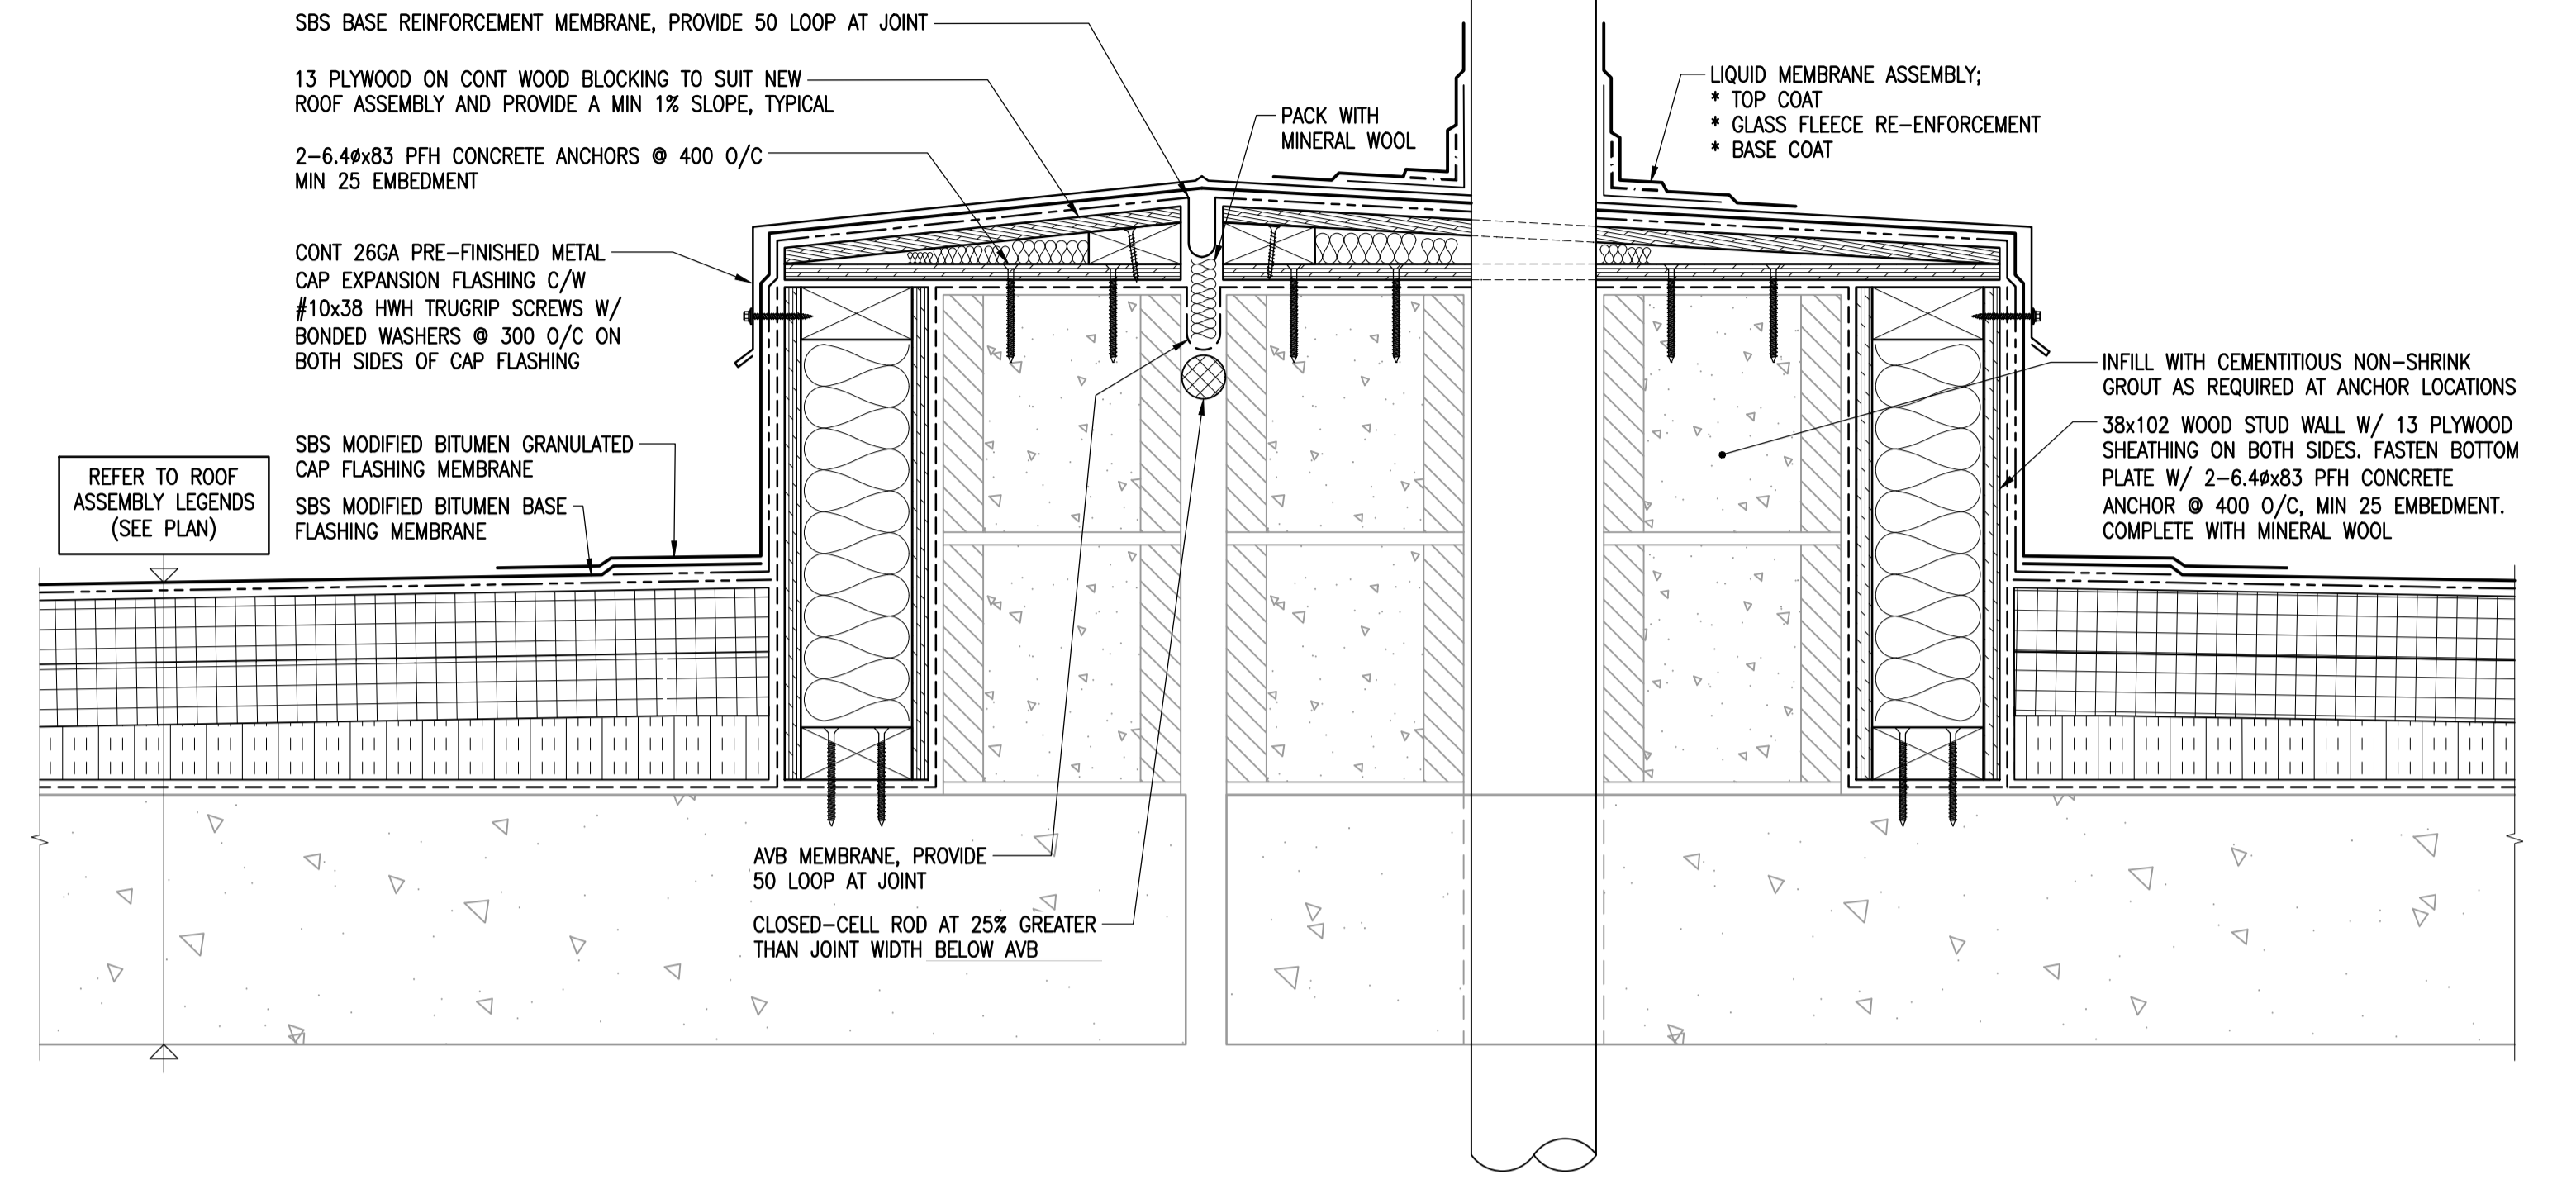


2 LOWER ROOF VENT/EXPANSION JOINT DETAIL  
1-0601B-00076-003 1:5

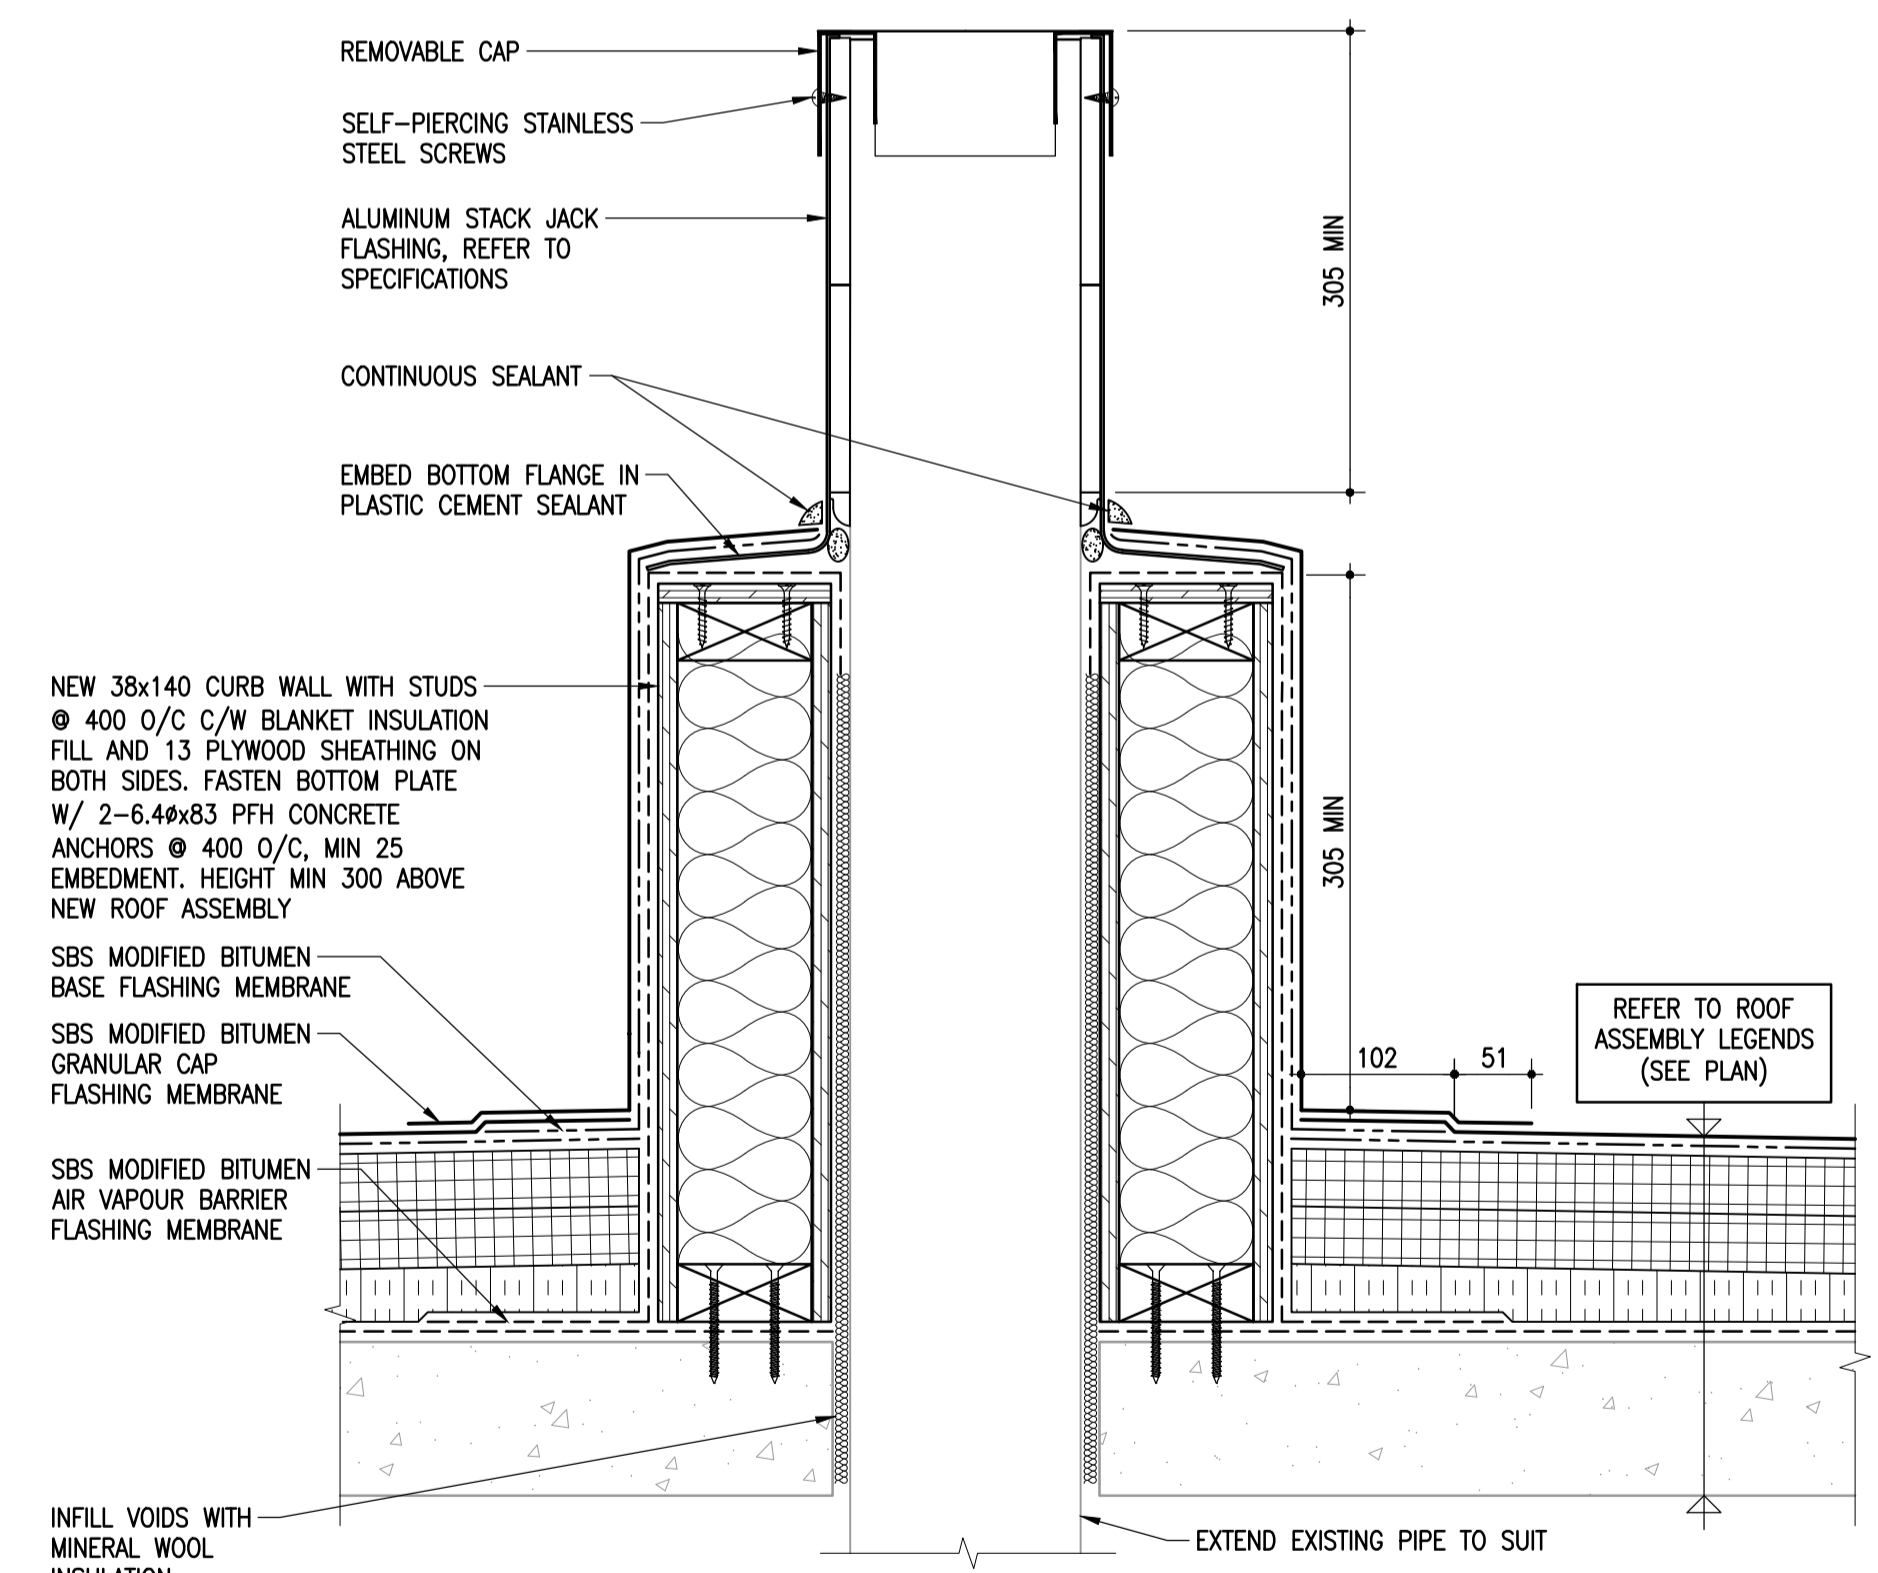


3 TYPICAL VENT/CURB DETAIL  
1-0601B-00076-003 1:5

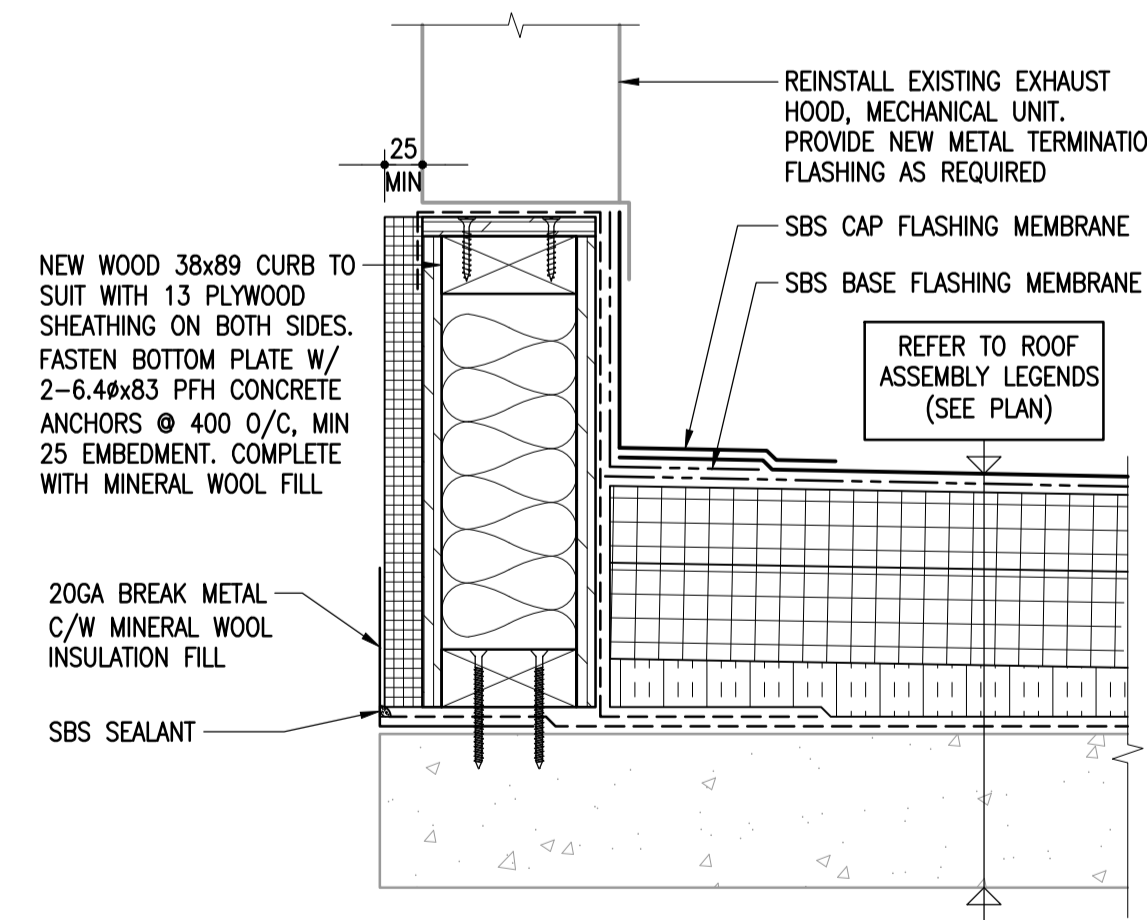

4 TYPICAL CURB DETAIL  
1-0601B-00076-003 1:5

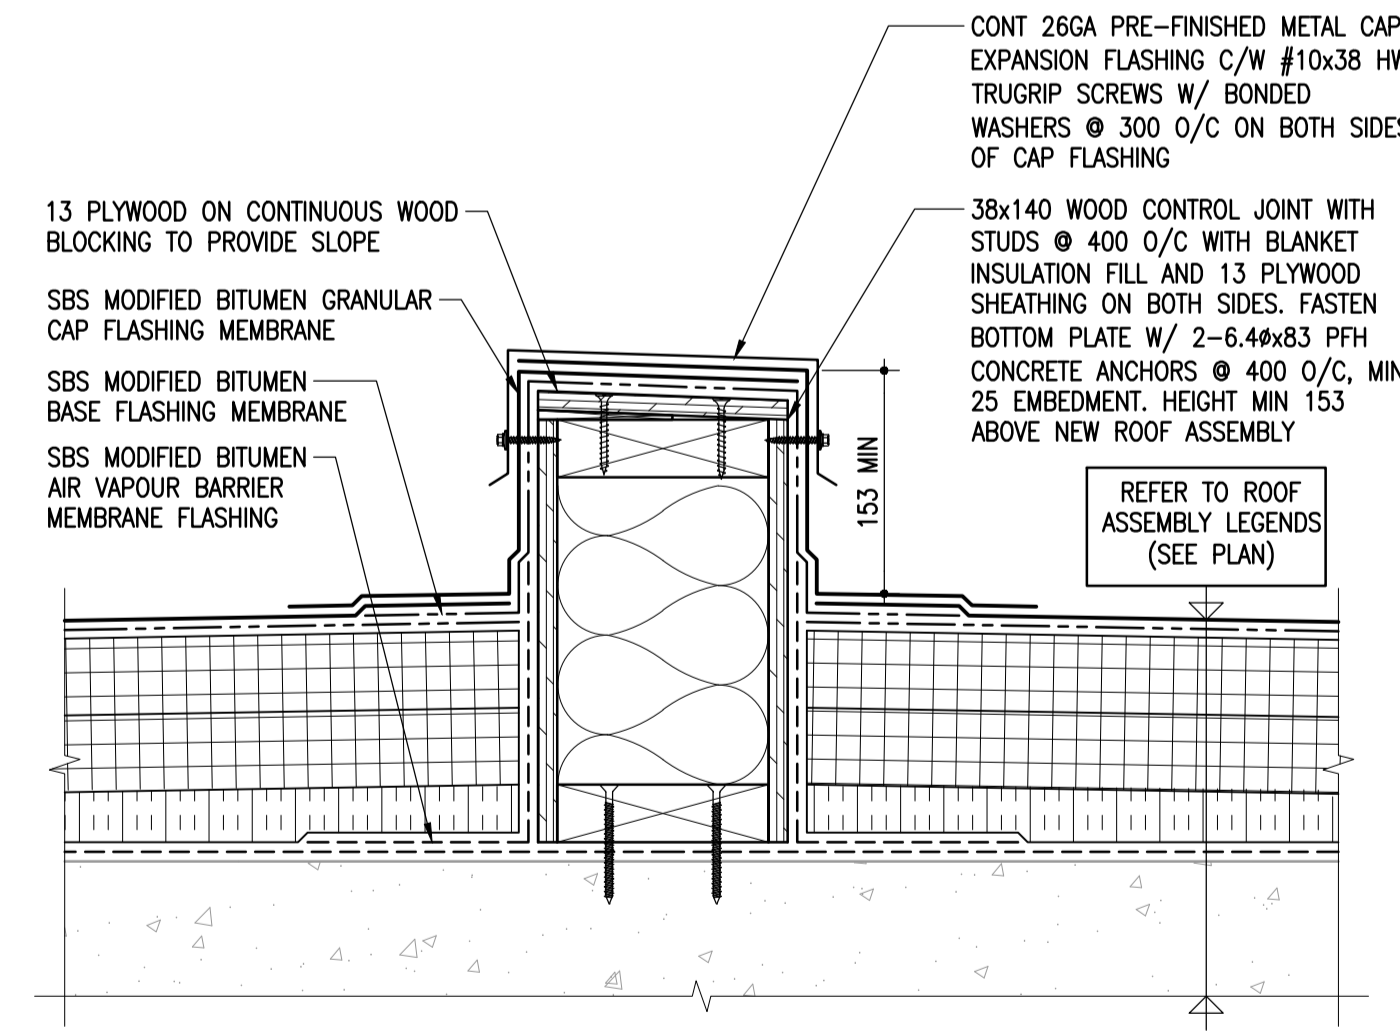

5 TYPICAL CONTROL JOINT DETAIL  
1-0601B-00076-003 1:5

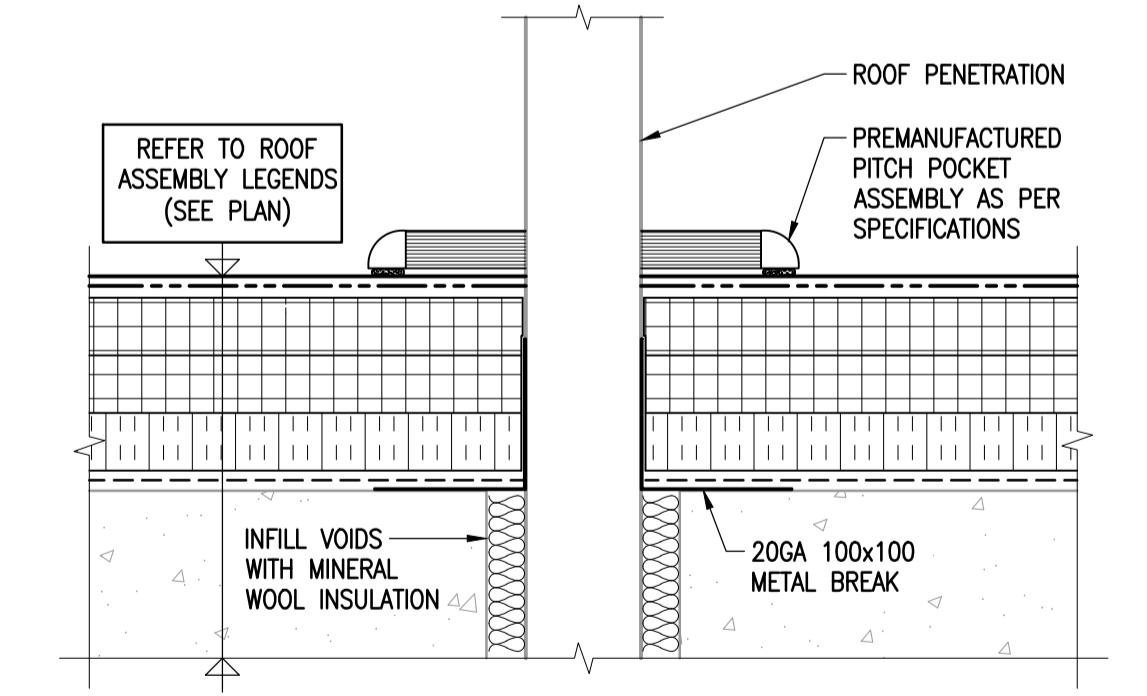

6 TYPICAL PITCH POCKET DETAIL  
1-0601B-00076-003 1:5

10		
9		
8		
7		
6		
5		
4	1-0601B-00070-001	BUILDING WA ROOF PLAN
3	1-0601B-00069-001	BUILDING WP ROOF PLAN
2	1-0601B-00068-001	BUILDING WF, WR, WO & WC ROOF PLAN
1	1-0601B-00004-001	BUILDING NOTES, SCHEDULE & LEGENDS
NO.	DRAWING NUMBER	REFERENCE DRAWING TITLE
REFERENCE DRAWINGS		

**ENGINEERS GEOSCIENTISTS MANITOBA**  
Certificate of Authorization  
Crosier Kilgour & Partners Ltd.  
No. 235

B.M. ELEV.					
DESIGNED BY	GJH	CHECKED BY	JAW	DATE	2023/03/21
DRAWN BY	LOL	APPROVED BY	GJH	DATE	2023/03/21
SCALE:	1:5	RELEASED FOR CONSTRUCTION BY:		DATE	2023/03/21
00	ISSUED FOR TENDER	23/03/21	GJH		
NO.	REVISIONS	DATE	BY	DATE	

ENGINEER'S SEAL  
PROVINCE OF MANITOBA  
REGISTERED PROFESSIONAL ENGINEER  
J.A. WELLS  
23/03/21  
CONSULTANT DRAWING NO. S4.3

**THE CITY OF WINNIPEG**  
WATER AND WASTE DEPARTMENT  
ENGINEERING DIVISION

DRINKING WATER TREATMENT PLANT  
MAIN BUILDING  
ROOF REPLACEMENT

BUILDING ROOF  
DETAILS 3 OF 9

CITY FILE NUMBER  
**W-1049**

SHEET 3 OF 9

CITY DRAWING NUMBER  
1-0601B-00076-003