


1 ROOF TIE-IN AT PARAPET
 1-0601B-80076-04 1:5 (AT VARYING ELEVATIONS)

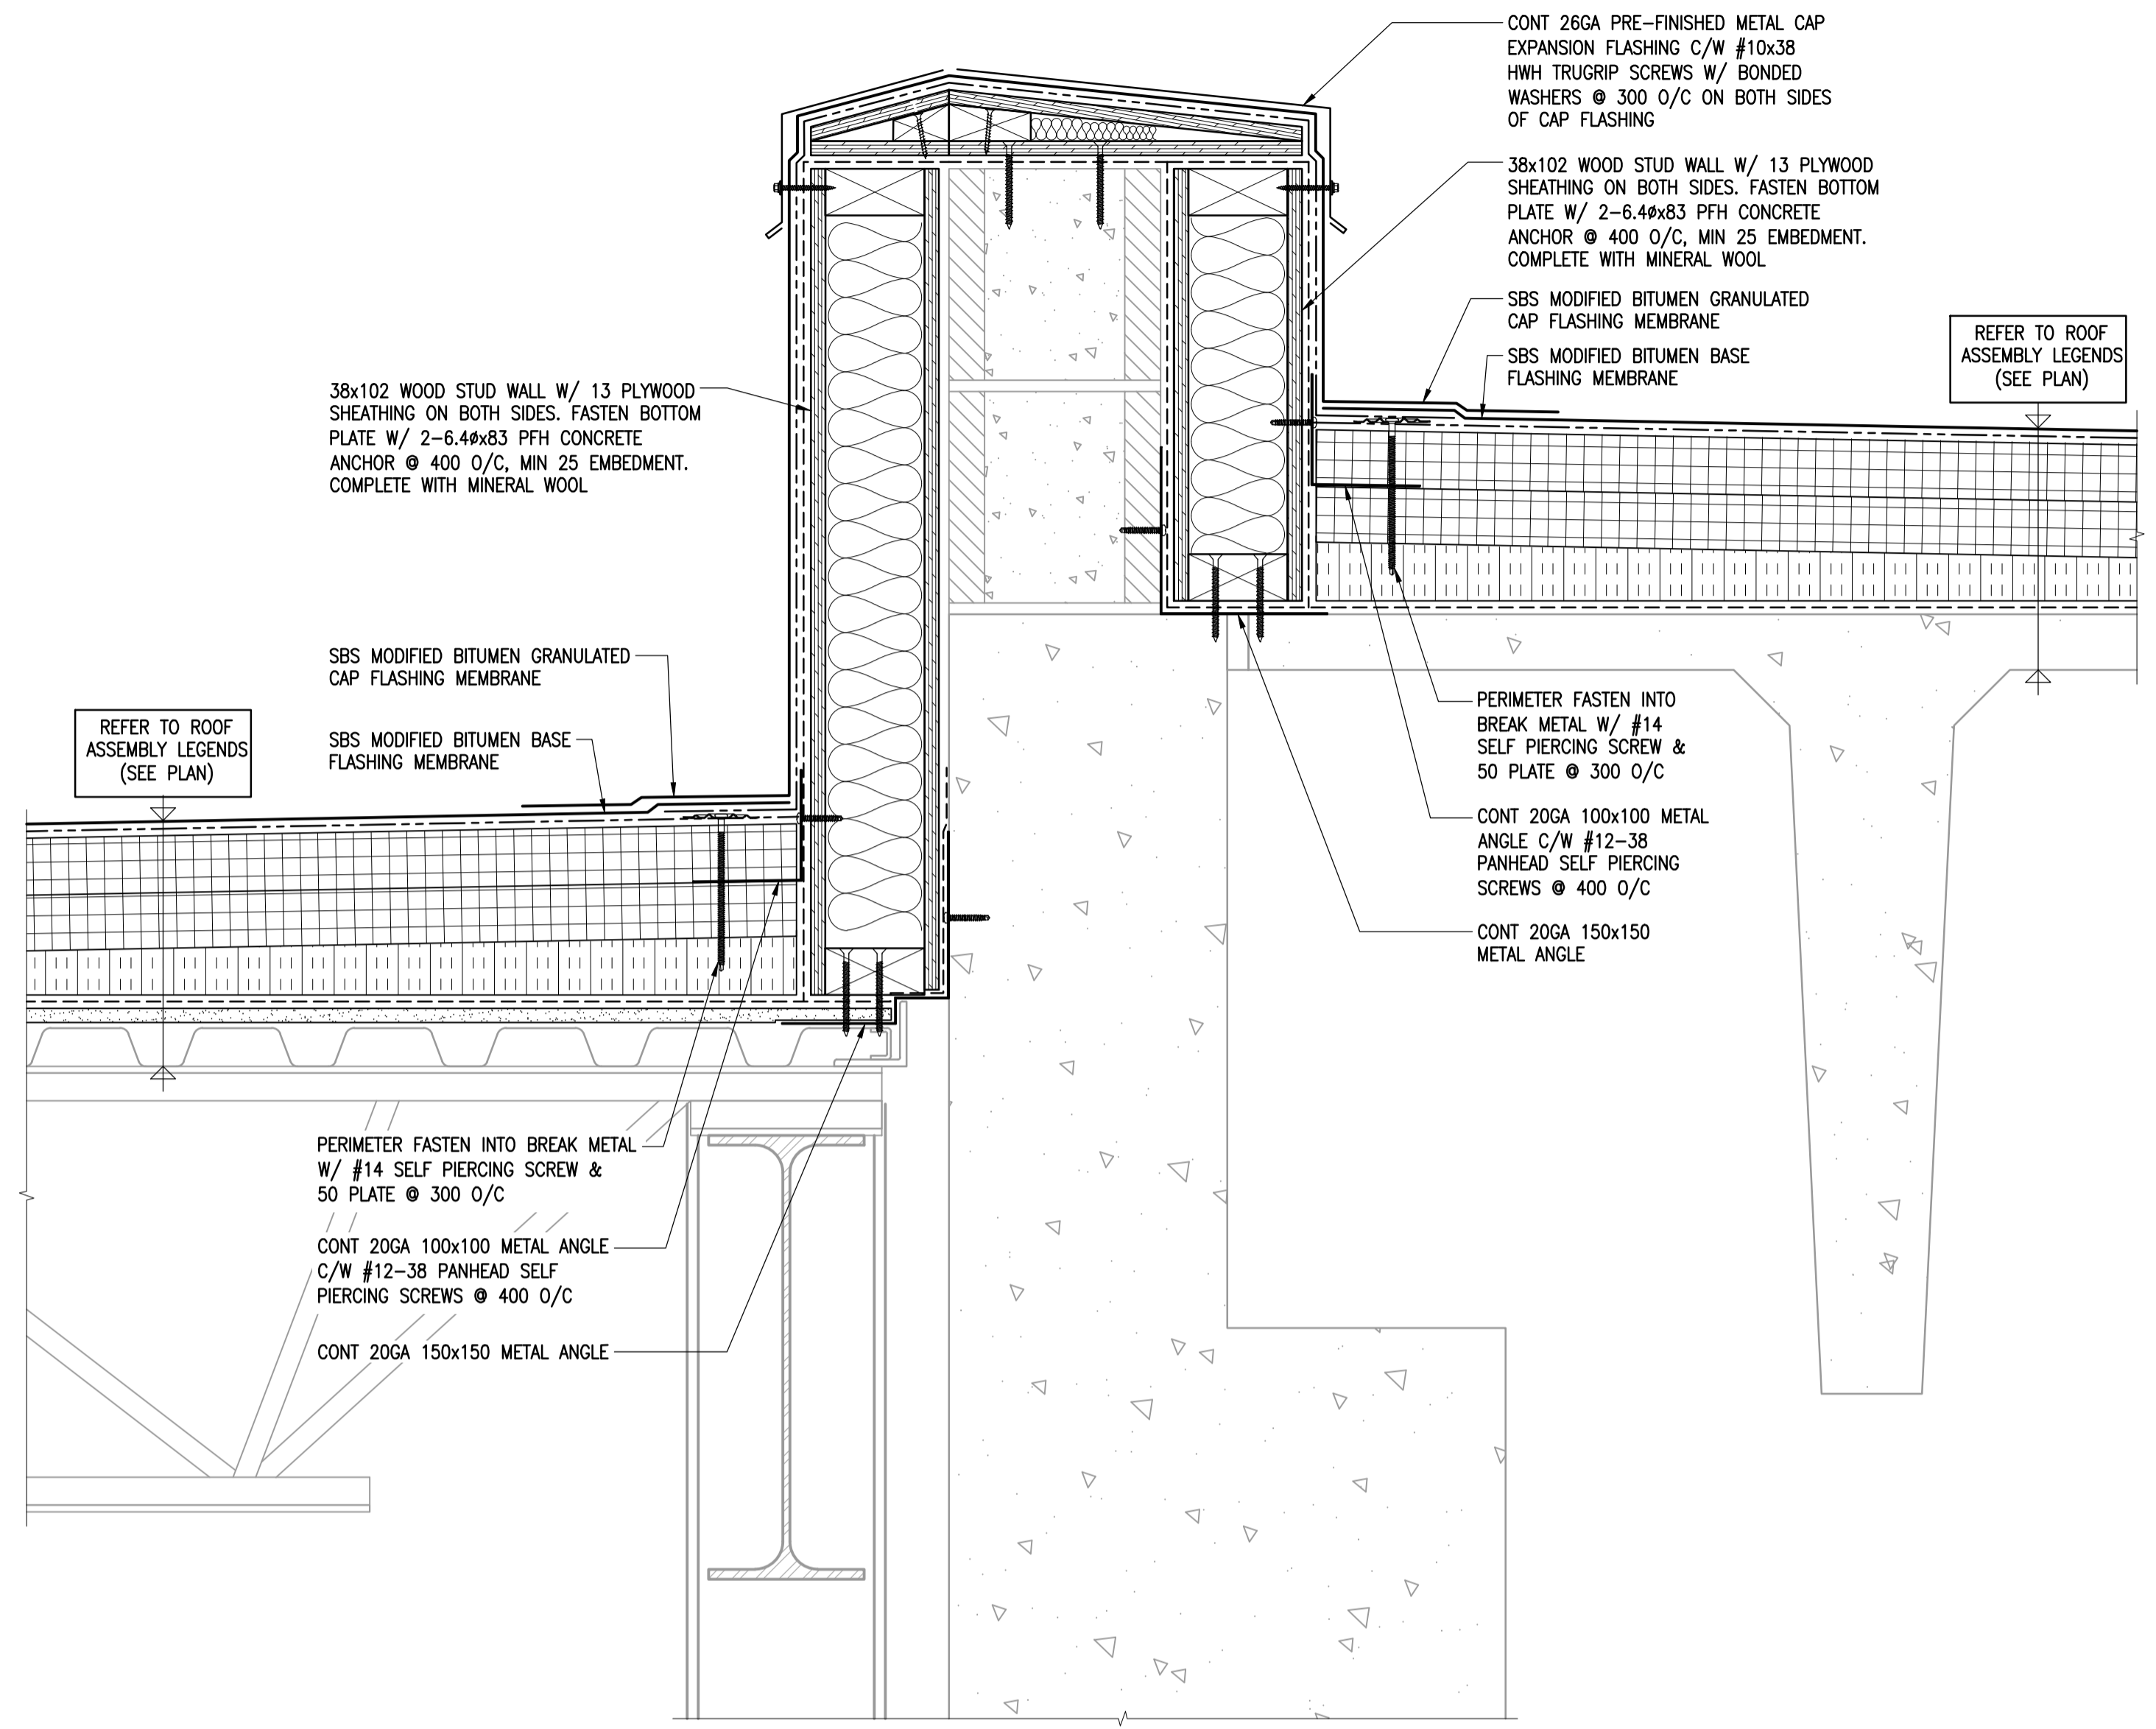

2 ROOF TIE-IN AT PARAPET
 1-0601B-80076-04 1:5 (AT VARYING ELEVATIONS)

10		
9		
8		
7		
6		
5		
4		
3		
2	1-0601B-80069-001	BUILDING WP ROOF PLAN
1	1-0601B-80004-001	BUILDING NOTES, SCHEDULE & LEGENDS
NO.	DRAWING NUMBER	REFERENCE DRAWING TITLE
REFERENCE DRAWINGS		

EG ENGINEERS GEOSCIENTISTS MANITOBA
 Certificate of Authorization
 Crosier Kilgour & Partners Ltd.
 No. 235

B.M. ELEV.					
00	ISSUED FOR TENDER	23/03/21	GJH		
NO.	REVISIONS	DATE	BY	DATE	
				2023/03/21	

ENGINEER'S SEAL
 PROVINCE OF MANITOBA
J.A. WELLS
 23/03/21
 REGISTERED PROFESSIONAL ENGINEER
 CONSULTANT DRAWING NO. S4.4

THE CITY OF WINNIPEG
 WATER AND WASTE DEPARTMENT
 ENGINEERING DIVISION
 DRINKING WATER TREATMENT PLANT
 MAIN BUILDING
 ROOF REPLACEMENT
 BUILDING ROOF DETAILS 4 OF 9
 CITY FILE NUMBER **W-1049**
 SHEET 4 OF 9
 CITY DRAWING NUMBER 1-0601B-80076-004