

WINNIPEG TRANSIT BRANDON GARAGE DIRECT CURRENT FAST CHARGING BUS STATIONS

600 Brandon Ave. Winnipeg, Manitoba, Canada

STANTEC PROJECT NO. 115423001

DATE OF ISSUE: 2023.09.18

ISSUED FOR CONSTRUCTION

PROJECT TEAM

ELECTRICAL CONSULTANT

STANTEC CONSULTING LTD.
 500-311 PORTAGE AVENUE
 WINNIPEG, MANITOBA R3B 2B9
 TEL (204) 489-5900
 FAX (204) 453-9012
 ENGINEER OF RECORD: ANDREI AROUTIUNOV

MECHANICAL CONSULTANT

STANTEC CONSULTING LTD.
 500-311 PORTAGE AVENUE
 WINNIPEG, MANITOBA R3B 2B9
 TEL (204) 489-5900
 FAX (204) 453-9012
 ENGINEER OF RECORD: RUSSELL LAVITT

STRUCTURAL CONSULTANT

STANTEC CONSULTING LTD.
 500-311 PORTAGE AVENUE
 WINNIPEG, MANITOBA R3B 2B9
 TEL (204) 489-5900
 FAX (204) 453-9012
 ENGINEER OF RECORD: BLAIR FRASER

ARCHITECTURAL CONSULTANT


STANTEC CONSULTING LTD.
 500-311 PORTAGE AVENUE
 WINNIPEG, MANITOBA R3B 2B9
 TEL (204) 489-5900
 FAX (204) 453-9012
 ARCHITECT OF RECORD: MARK GREATRIX

ARCHITECTURAL DRAWING LIST	
A-101	PARTIAL MAIN FLOOR PLAN - ARCHITECTURAL - NEW CONSTRUCTION, ELEVATIONS, DETAILS

STRUCTURAL DRAWING LIST	
S-101	STRUCTURAL DETAILS

MECHANICAL DRAWING LIST	
M-001	MECHANICAL SYMBOL LEGEND
M-101	PARTIAL MAIN FLOOR PLAN - MECHANICAL - NEW CONSTRUCTION

ELECTRICAL DRAWING LIST	
E-001	DRAWING LIST AND SYMBOL LEGEND
E-002	ELECTRICAL SITE PLAN GENERAL ARRANGEMENT
E-101	ELECTRICAL SERVICE EQUIPMENT - DEMOLITION
E-201	ELECTRICAL SERVICE EQUIPMENT - NEW CONSTRUCTION
E-202	PARTIAL MAIN FLOOR PLAN - ELECTRICAL - NEW CONSTRUCTION
E-203	PARTIAL MAIN FLOOR PLAN - ELECTRICAL - NEW CONSTRUCTION
E-204	PARTIAL MAIN FLOOR PLAN - ELECTRICAL - NEW CONSTRUCTION
E-205	ENLARGED STORAGE ROOM EQUIPMENT LAYOUT - NEW CONSTRUCTION
E-301	SINGLE LINE DIAGRAM - DEMOLITION
E-302	SINGLE LINE DIAGRAM - NEW CONSTRUCTION
E-303	ELECTRICAL DETAILS
E-304	ELECTRICAL DETAILS

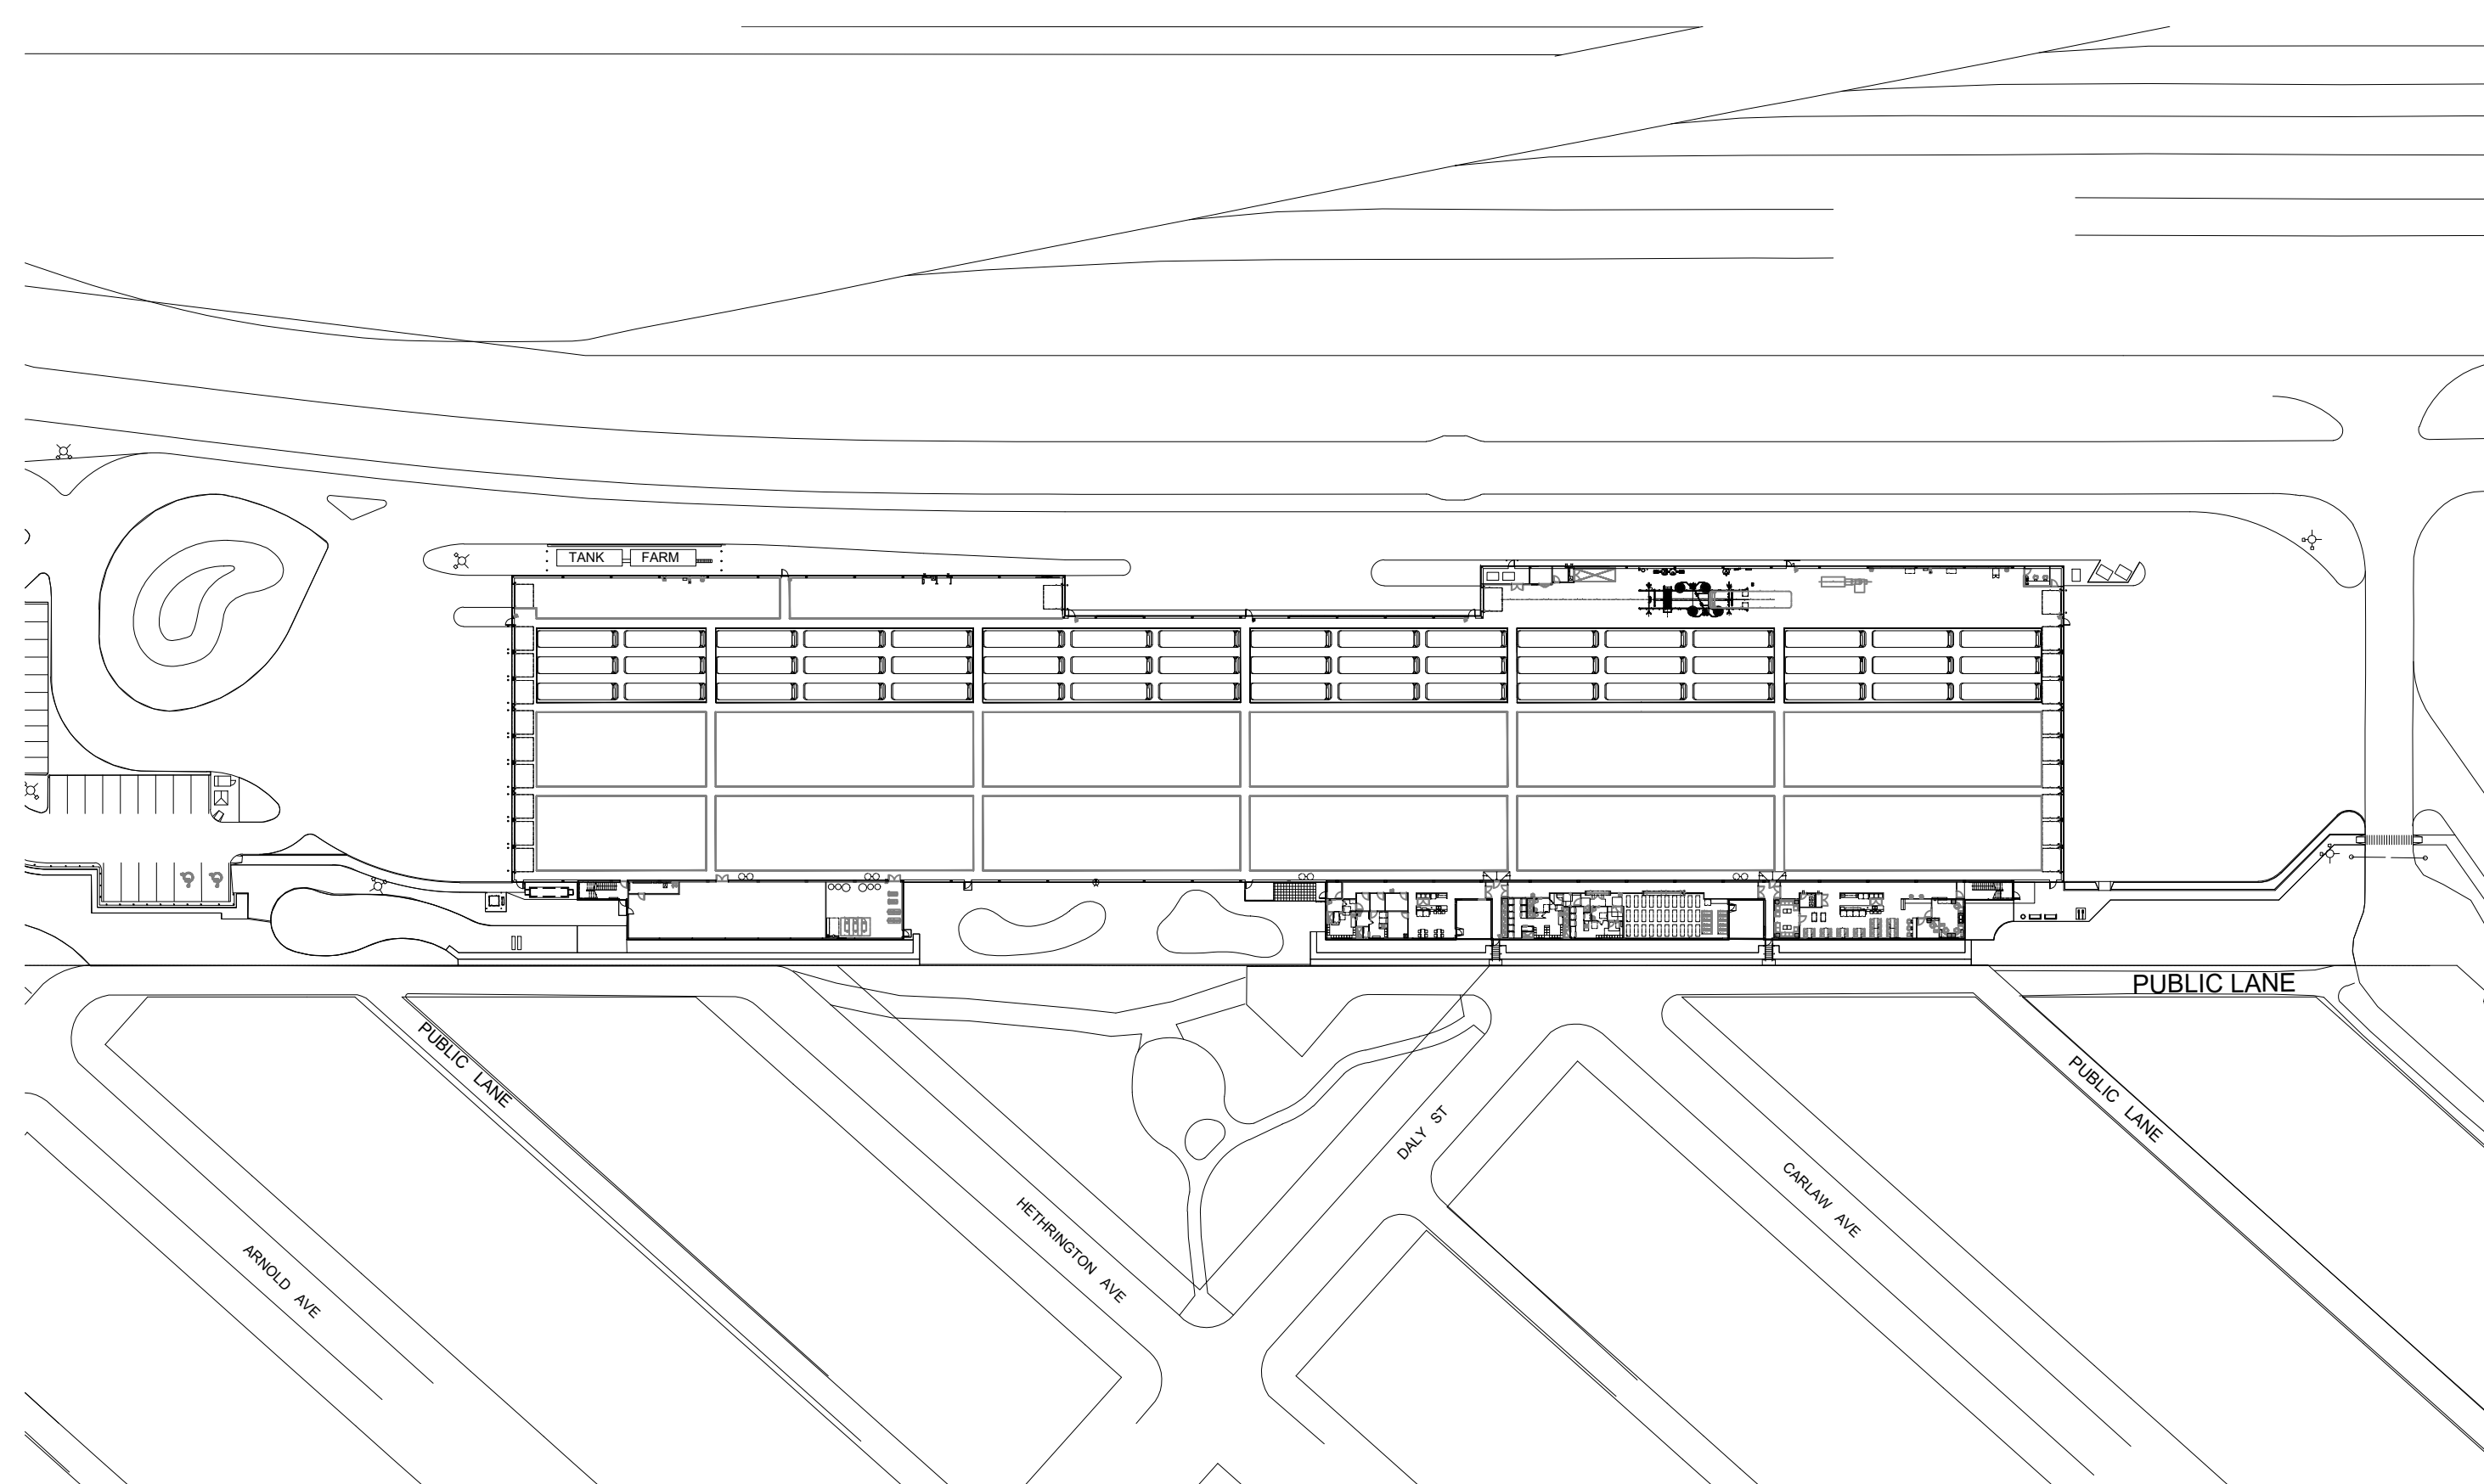

Legend

Notes

Revision	By	Appd.	YYMM.DD
0		CB	AA 23.09.18
Issued			By Appd. YYMM.DD
File Name: 115423001_e.g-000m -cover CB AA 22.05.27			
	Dwn.	Chkd.	Dsgn. YYMM.DD

Permit-Seal



Client/Project
 WINNIPEG TRANSIT DIRECT CURRENT FAST
 CHARGING BUS STATIONS BRANDON GARAGE

600 Brandon Ave. Winnipeg, Manitoba

Title
 COVER SHEET

Project No. 144523001	Scale As Indicated
Drawing No. G-000	Sheet 0 of 12
	Revision 0